
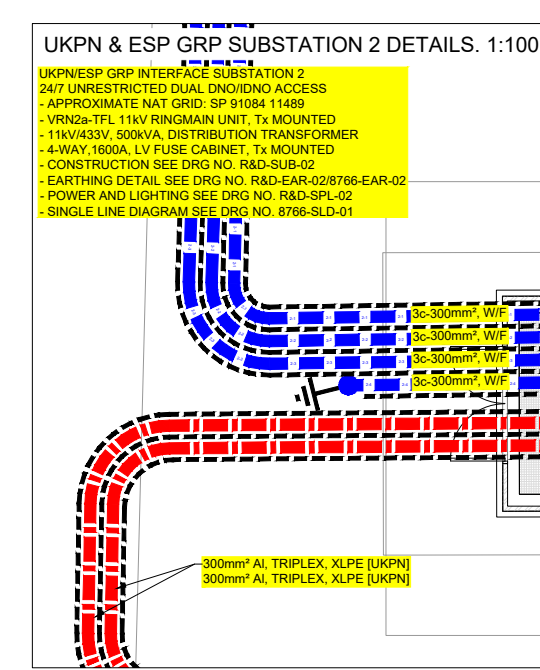
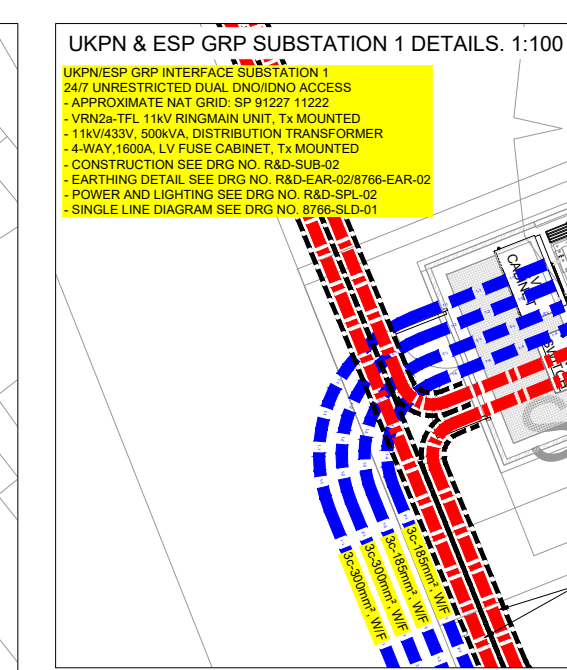
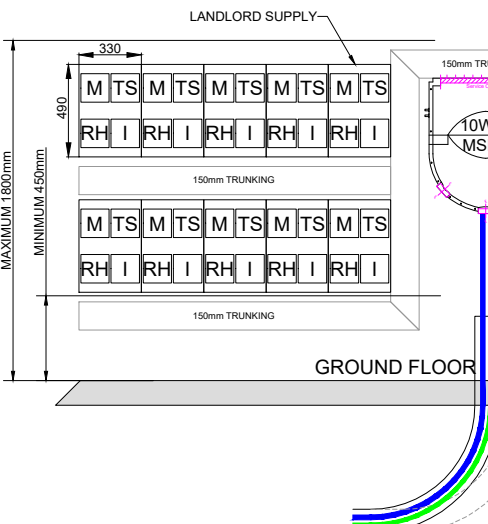
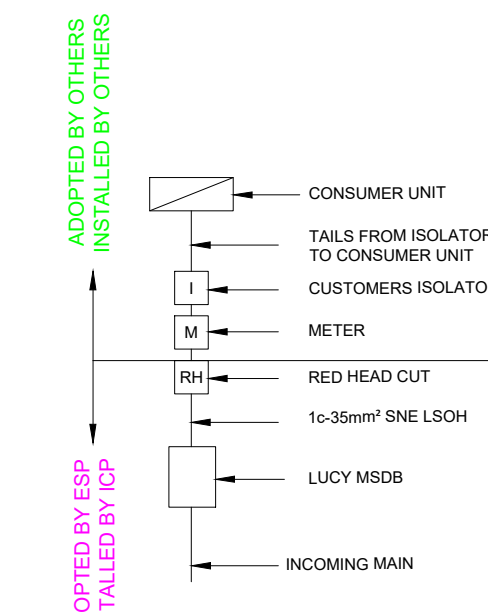
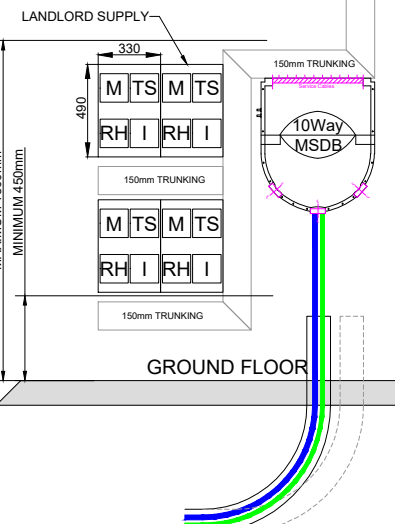
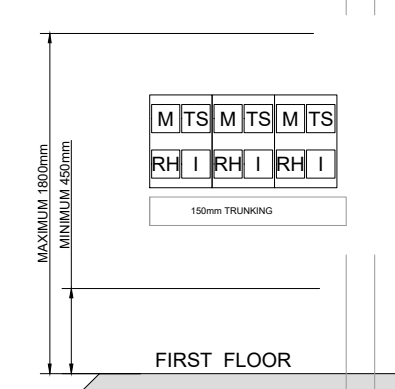
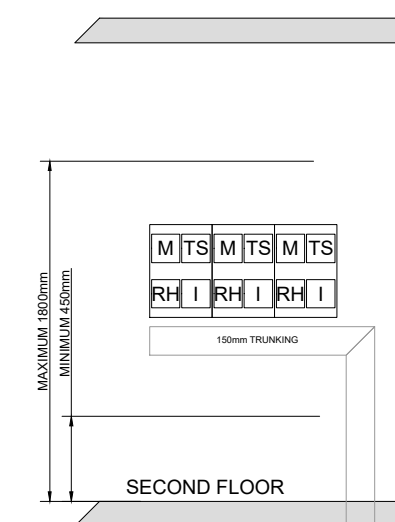
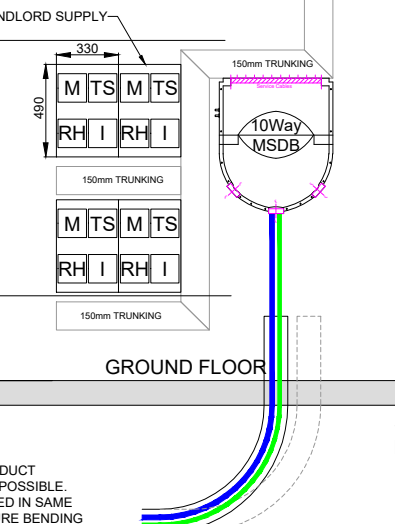
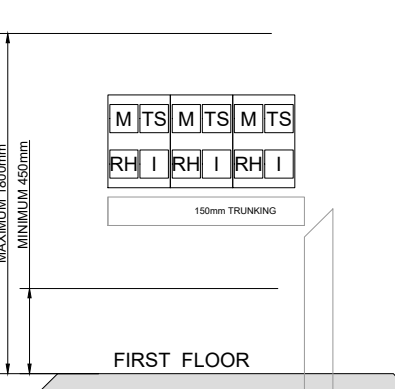
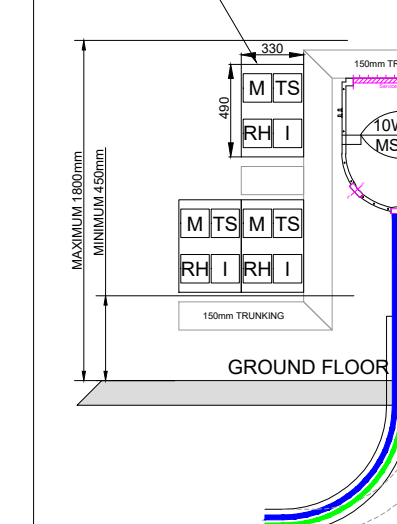
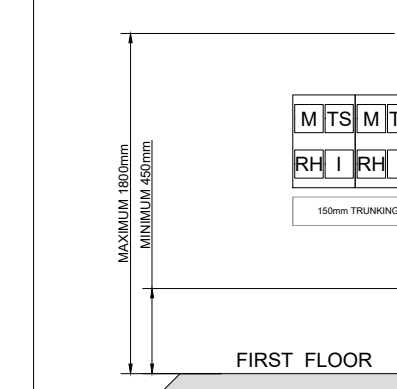
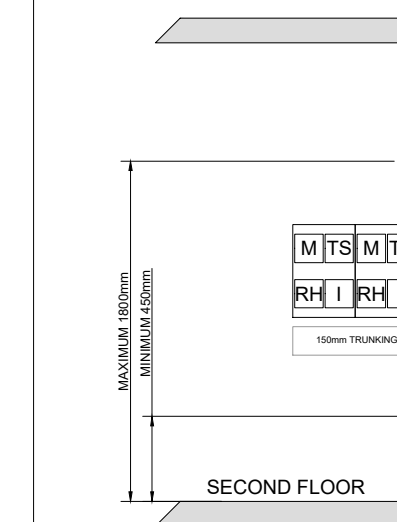
 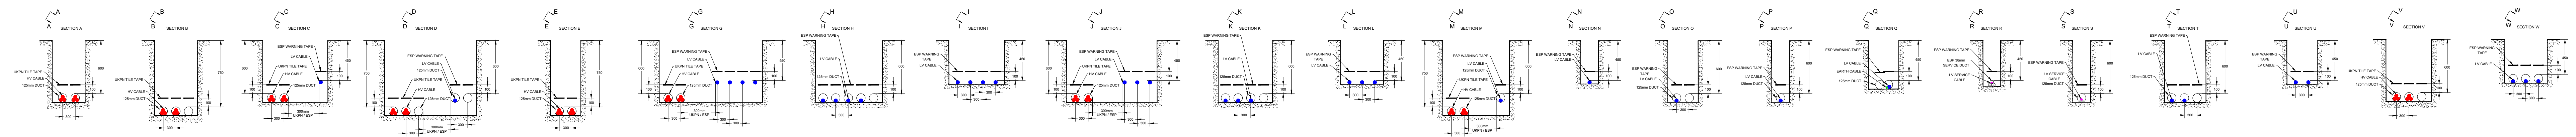




L	ILLUMINATE SIGN AREA & EPPY NOW UNREMOVED BY 2/27/2016	06/08/2021	KW
L	BLOCK A (211-216) MEET ROOM REMOVED BY 3/1/2016 FUTURE AMENDED INTO SLOTT & LOCATED TAKEN BY PL (8) (NORTH)	03/07/2021	CT
J	SPACE HY DUCT & INTERLOCATED GAS IN RELOCATED BY BLOCK C	08/04/2021	KW
J	STREET LIGHT LOCATED, SUB RELOCATED, PLOT 1 REASSIGNED & TAKEN BY PL (8) (NORTH)	10/03/2021	KW
L	STREET LIGHT LOCATED AMENDED REMOVED BY 2/27/2021	2/27/2021	KW
G	MARKERS ADDED BY 8/05 8:00 - FEDERAL PHILLIPS ADDED SITE 16, STREET LIGHTS REMOVED & 3 ADDED TO 202-100-100	09/07/2020	KW
L	SECTION OF HY MAIN AMENDED & SECTION OF HY MAIN AMENDED STREETLIGHT MAIN REMOVED & SUPPORTED OFF. THE AMENDED SECTION OF HY MAIN AMENDED FROM C TO SITE BOUNDARY (NORTH)	20/03/2021	CT
L	REMOVED LAYOUT WITH REMOVED CHANGES & SITE 1 AMENDED TO: GRP C	03/03/2020	DS
D	MINOR AMENDMENTS MADE TO ICP PROJECT	11/12/2019	DS
C	HY ROUTE AMENDED	21/01/2020	DS
L	AMENDED TO ICP REVIEW COMMENTS DATE 2/20/2021	13/10/2019	DS
REV	REVISION NOTES	DATE	ENG

DRAWING KEY	
SOLID LINE - EXISTING CABLEING. CABLE DEFINES VOLTAGE RATING	VARIABLES
DASHED LINE - PROPOSED CABLEING. CABLE DEFINES VOLTAGE RATING	VARIABLES
PROPOSED HV MAIN CABLEING	RED
PROPOSED LV MAIN CABLEING	BLUE
PROPOSED LV SERVICE CABLEING	PINK
PROPOSED CABLE DUCT	==
PROPOSED EARTHING CABLE	
PROPOSED EARTHING ROD(S)	
S1 (BREECH JUNT) S1/S2 (STRAIGHT S1/S2 BOTTLE END) SERVICE JUNT	
CABLE DEFINES VOLTAGE RATING	
PHASE ALLOCATION	
METER POSITIONS	
SITE BOUNDARY	PURPLE
STREETLIGHTS	
TRIGGER SIGNAL	
ILLUMINATED STREET SIGN	

Design supplied for and on behalf of:

TRICONNEX



Client	TriComms	Client Ref	X079
Site Address	Iskildon Way, Tring, Herts, HP23 4DY		
Title	Site Plan with Cable Routes		
Drawn By	DS	Date	24/10/2019
Checked By	DK	Date	25/10/2019
Approved By	ICP	Date	
Scale	VARIES @ A0		
Revision	L		
Drawing No	8766/SP/02		