

HEALTH & SAFETY:



ALL WORKS TO BE CARRIED OUT BY A CONTRACTOR COMPETENT TO UNDERTAKE THE CONSTRUCTION OF WORKS AS INDICATED ON THIS DRAWING. THIS DRAWING IS TO BE READ IN CONJUNCTION WITH THE JOB SPECIFIC RISK ASSESSMENT. THE HAZARDS NOTED ARE IN ADDITION TO THE NORMAL HAZARDS AND RISKS FACED BY A COMPETENT CONTRACTOR WHEN DEALING WITH THE TYPE OF WORKS DETAILED ON THIS DRAWING.

LOCATION PLAN 1:1250



LEGEND

- DENOTES S278 AGREEMENT EXTENTS
- DENOTES NEW AREA OFFERED FOR ADOPTION
- DENOTES HIGHWAY DRAINAGE
- DENOTES GULLY CONNECTION
- exG □ EXISTING GULLY POSITION
- G □ PROPOSED HIGHWAY GULLY
- 70m2 GULLY CATCHMENT AREA

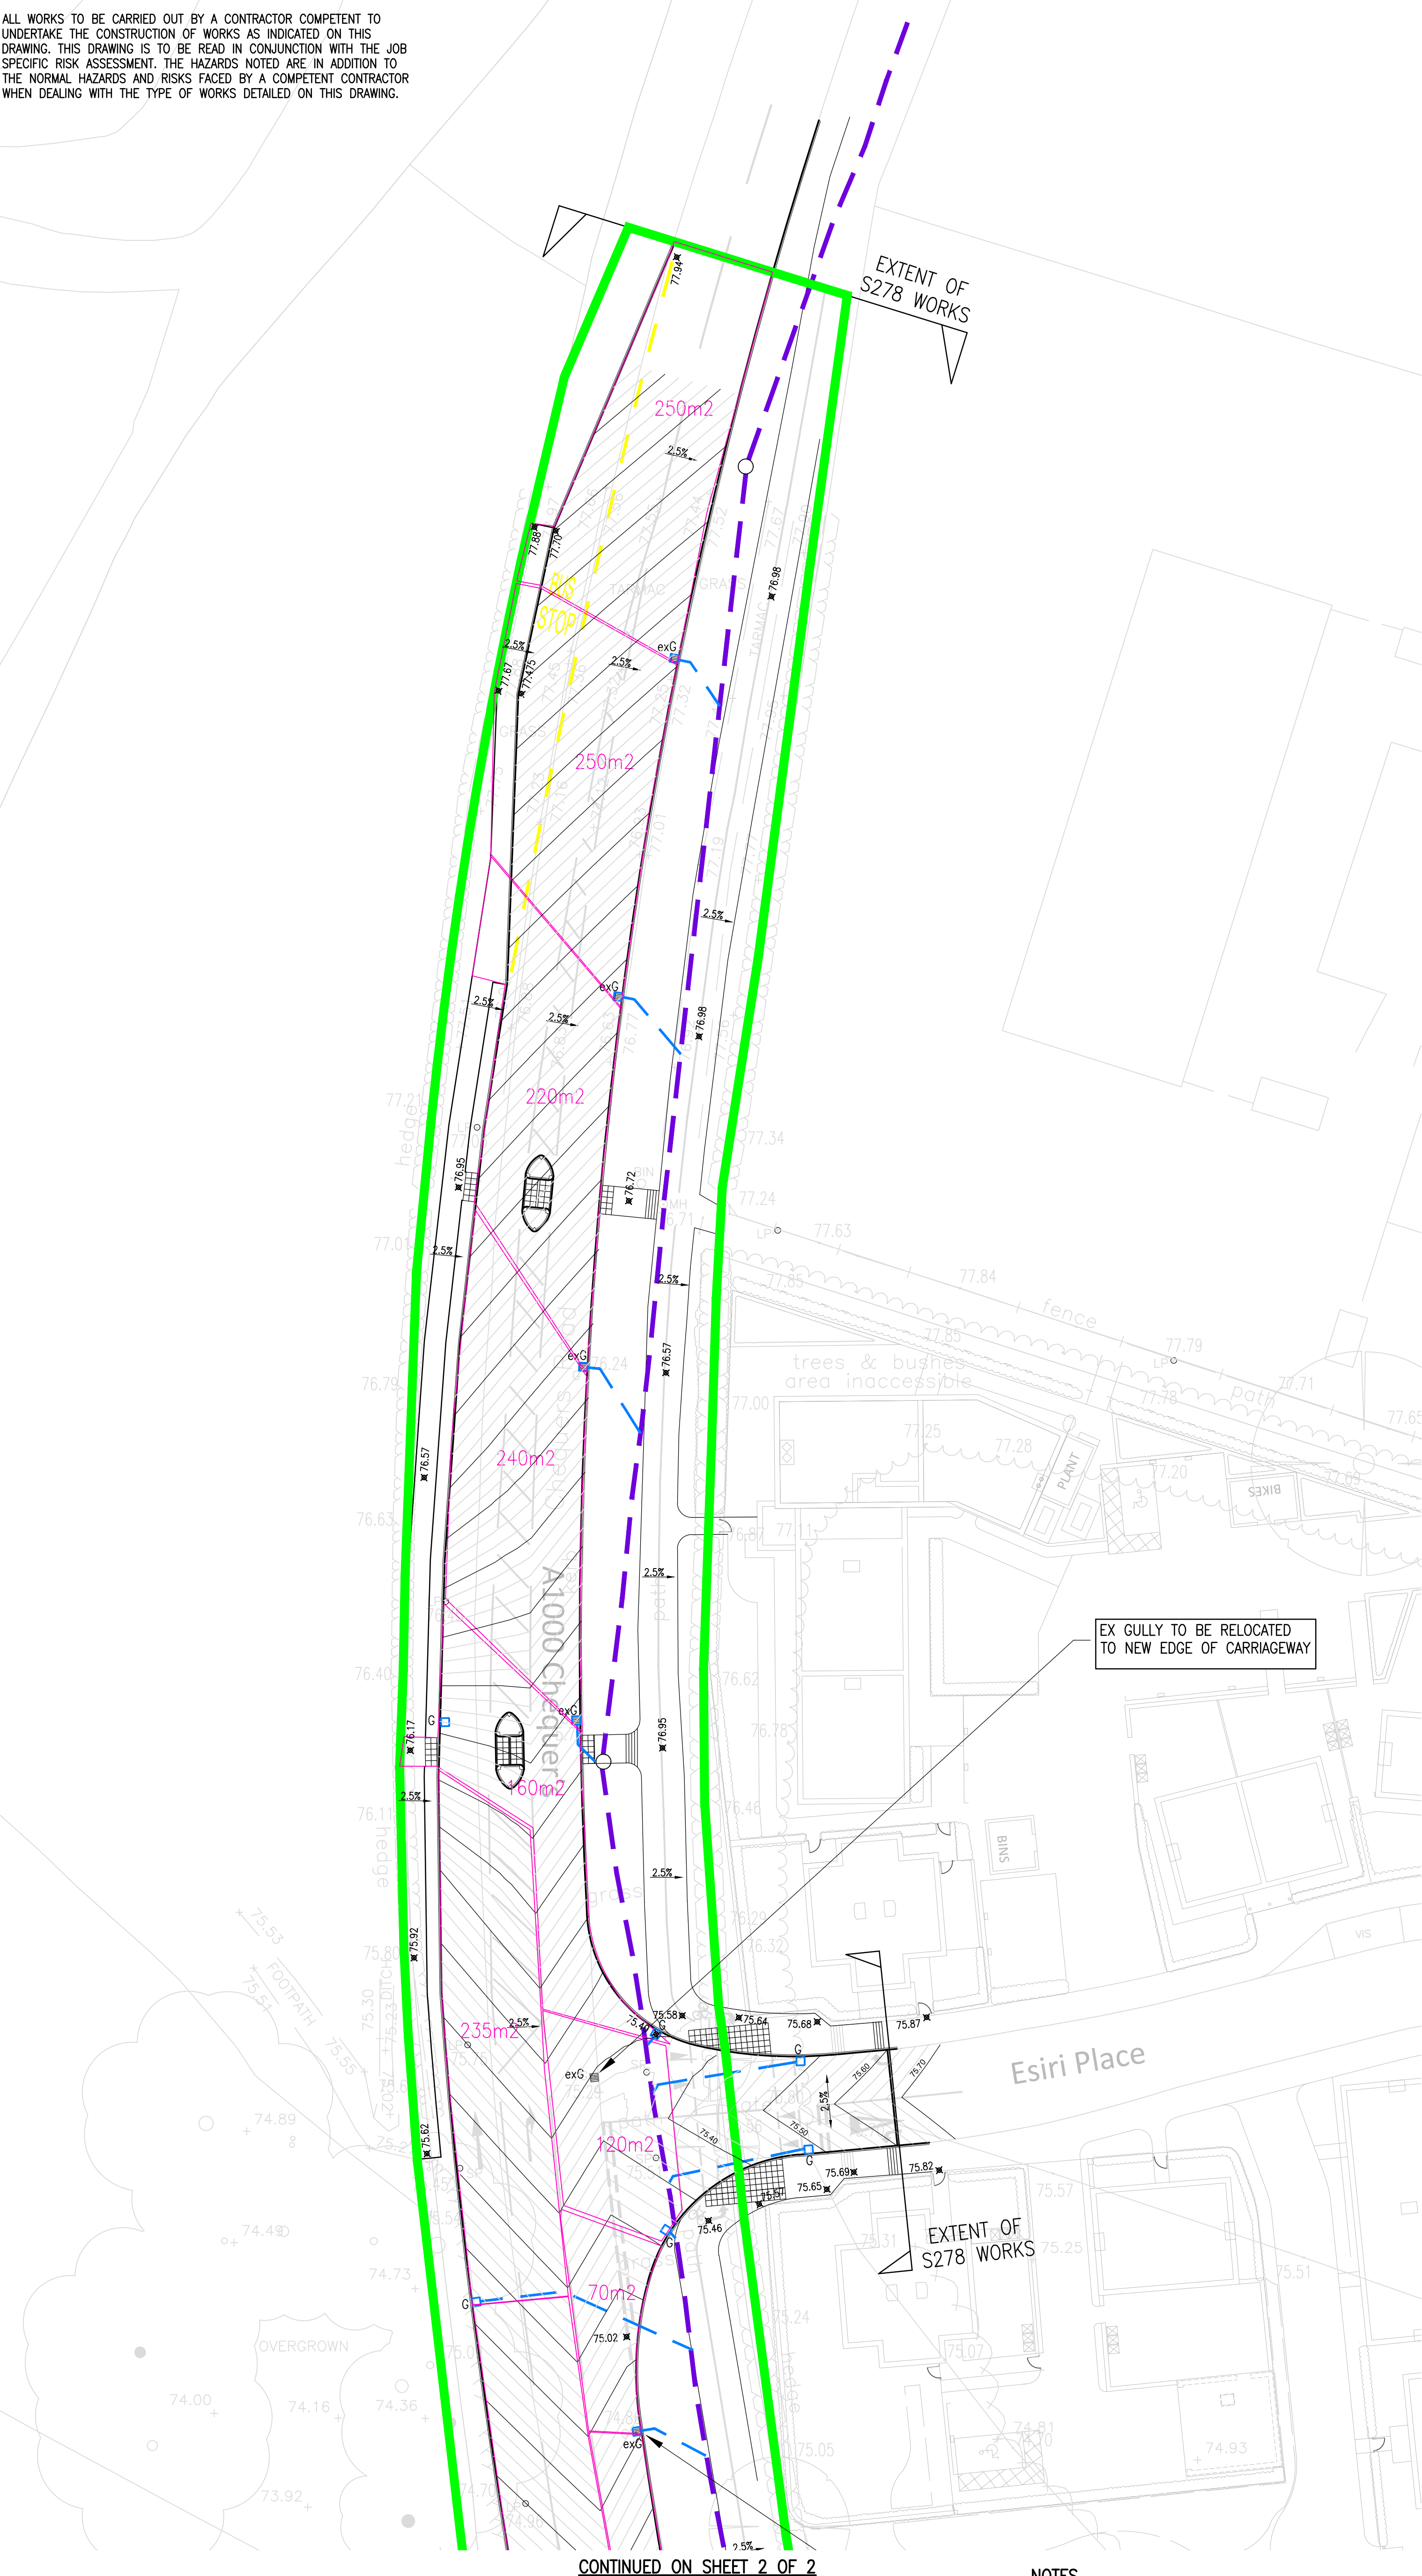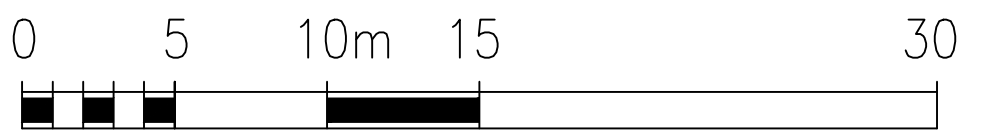

CONTINUED ON SHEET 2 OF 2


NOTES

- THIS DRAWING IS COPYRIGHT.
- DO NOT SCALE THIS DRAWING. THE CONTRACTOR IS TO BRING TO THE NOTICE OF THE ENGINEER ANY DISCREPANCIES CONTAINED IN THIS DRAWING PRIOR TO WORK COMMENCEMENT.
- THIS DRAWING IS TO BE READ IN CONJUNCTION WITH ALL RELEVANT ARCHITECTS, ENGINEERS AND SPECIALIST SUB-CONTRACTORS DRAWINGS AND THE SPECIFICATION.
- ALL SETTING OUT TO BE IN ACCORDANCE WITH THE ENGINEERS DRAWINGS. CONTRACTOR TO CHECK AND IDENTIFY ANY DISCREPANCIES TO ENGINEER. DIMENSIONS MUST NOT BE SCALED.

P2	23/08/2024	ADDITIONAL GULLY SHOWN	DC
P1	27/06/2024	INITIAL ISSUE	DC
rev	date	description	initials

Project GASCOYNE ESTATES, CRESWICK

Client / Architect

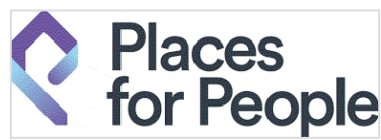

Title
S278 HIGHWAY DRAINAGE LAYOUT
SHT 1 OF 2



Hampshire Office:
Dewey House, 55 High Street,
Ringwood, Hampshire BH24 1AE
Telephone: 01425 484400
Facsimile: 01425 484409
Email: admin@reuby-stagg.co.uk

date	MAR 2023	scale	1:250	size	A1	project no.	10650	drawing no.	208	revision	P2
drawn	DC	checked	MPD								