

CONTINUED ON SHEET 1 OF 2

HEALTH & SAFETY:

ALL WORKS TO BE CARRIED OUT BY A CONTRACTOR COMPETENT TO UNDERTAKE THE CONSTRUCTION OF WORKS AS INDICATED ON THIS DRAWING. THIS DRAWING IS TO BE READ IN CONJUNCTION WITH THE JOB SPECIFIC RISK ASSESSMENT. THE HAZARDS NOTED ARE IN ADDITION TO THE NORMAL HAZARDS AND RISKS FACED BY A COMPETENT CONTRACTOR WHEN DEALING WITH THE TYPE OF WORKS DETAILED ON THIS DRAWING.

EX GULLY TO BE REMAIN AT CURRENT LOCATION

EX GULLY TO BE RELOCATED TO NEW KERB EDGE

EX GULLY TO BE RELOCATED TO NEW EDGE OF CARRIAGEWAY

EX GULLY TO BE RELOCATED TO END OF BUS LAYBY


LOCATION PLAN 1:1250



LEGEND	
	DENOTES S278 AGREEMENT EXTENTS
	DENOTES NEW AREA OFFERED FOR ADOPTION
	DENOTES HIGHWAY DRAINAGE
	DENOTES GULLY CONNECTION
	EXISTING GULLY POSITION
	PROPOSED HIGHWAY GULLY
	GULLY CATCHMENT AREA

NOTES

- THIS DRAWING IS COPYRIGHT.
- DO NOT SCALE THIS DRAWING. THE CONTRACTOR IS TO BRING TO THE NOTICE OF THE ENGINEER ANY DISCREPANCIES CONTAINED IN THIS DRAWING PRIOR TO WORK COMMENCEMENT.
- THIS DRAWING IS TO BE READ IN CONJUNCTION WITH ALL RELEVANT ARCHITECTS, ENGINEERS AND SPECIALIST SUB-CONTRACTORS DRAWINGS AND THE SPECIFICATION.
- ALL SETTING OUT TO BE IN ACCORDANCE WITH THE ENGINEERS DRAWINGS. CONTRACTOR TO CHECK AND IDENTIFY ANY DISCREPANCIES TO ENGINEER. DIMENSIONS MUST NOT BE SCALED.

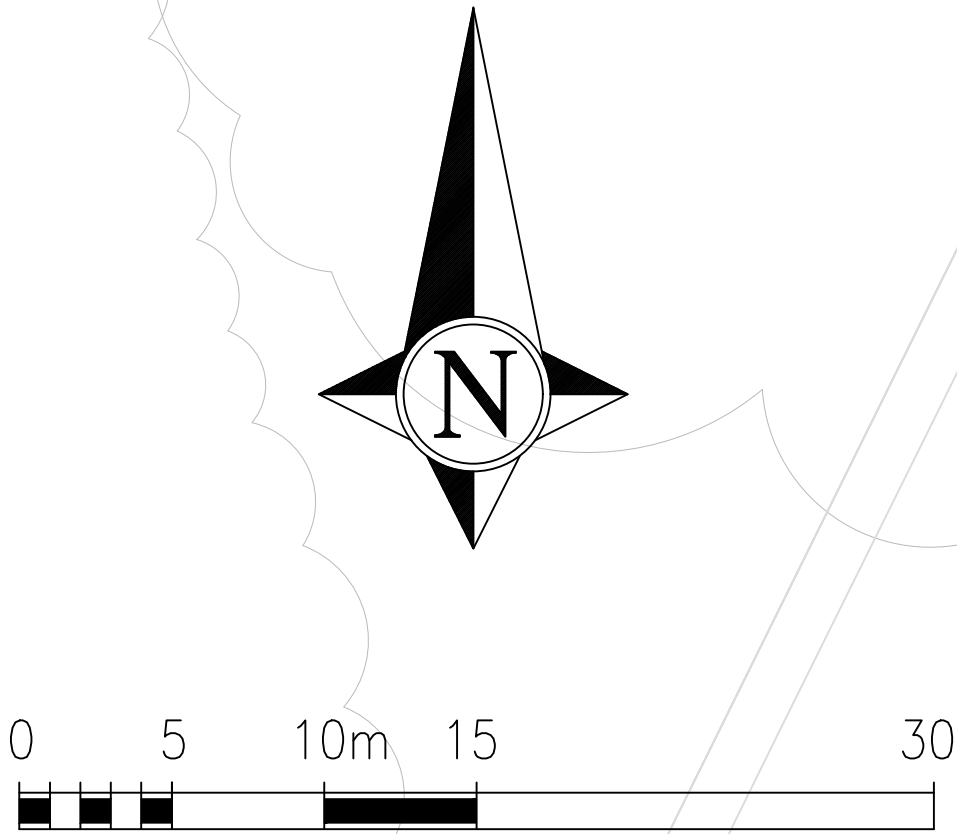

EXTENT OF S278 WORKS

P2 P1 rev	23/08/2024 27/06/2024 date	ADDITIONAL GULLY SHOWN INITIAL ISSUE description	DC DC initials			
Project GASCOYNE ESTATES, CRESWICK						
Client / Architect Places for People		Title S278 HIGHWAY DRAINAGE LAYOUT SHT 2 OF 2				
REUBY & STAGG LTD. CONSULTING CIVIL & STRUCTURAL ENGINEERS		Hampshire Office: Dewey House, 55 High Street, Ringwood, Hampshire BH24 1AJ Telephone: 01425 484400 Facsimile: 01425 484409 Email: admin@reuby-stagg.co.uk				
date drawn checked	JUN 2024 DC MPD	scale 1:250	size A1	project no. 10650	drawing no. 209	revision P2