


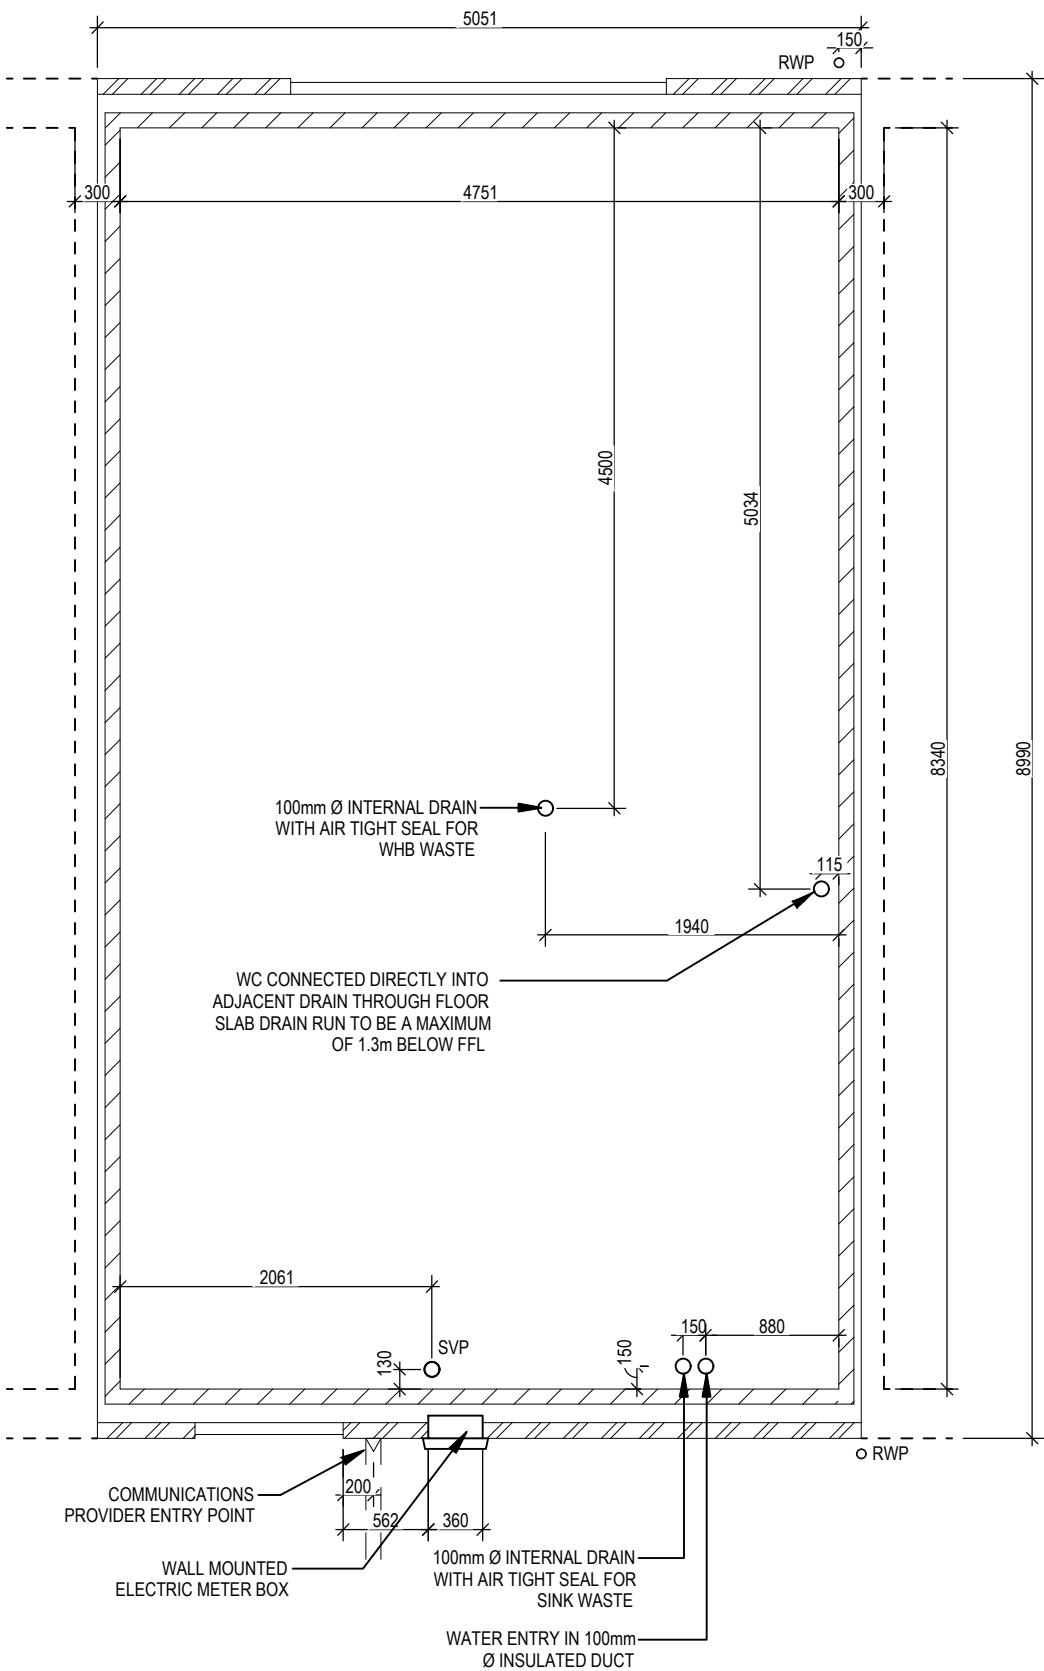

2B4P M4(2)
Mid
G SERIES

Slab Penetration Layout

Scale	DCC	Dwg No
1 : 50	2	160
Date		Dwg Rev
Mar 2023		

Window Schedule						
Ref	Frame Width	Frame Height	Int Block Opening	Comments	P1A - Glazing	PAS 24 - Locking
W01	1273	1040	1283		-	Yes

REFER TO TM59 CALCULATION FOR OPENINGS REMOVING EXCESS HEAT. ALL BEDROOM WINDOWS DESIGNED TO 1.1M ABOVE FFL WITH A BUILD TOLERANCE +/-100MM. WINDOWS WITH LOWER OPENING HEIGHTS ARE EXCLUDED FROM TM59 CALCULATION AND REQUIRED FOR MEANS OF ESCAPE.

NOTE: ALL WINDOWS TO BE FITTED WITH OVER-FRAME TRICKLE VENTILATORS. FOR MINIMUM TRICKLE VENTILATION RATES FOR EACH WINDOW WIDTH SEE WINDOW AND DOOR SCHEDULE.

HANDLES - ALL WINDOW HANDLES TO BE FITTED AT A MXIMUM OF 1400MM ABOVE FFL UNLESS OTHERWISE STATED IN THE COMMENTS COLUMN.

ALL WINDOWS TO BE SAFE CLEAN IN ACCORDANCE WITH B.S. 8213.

WHOLE HOUSE TRICKLE VENTILATION REQUIREMENT STATED ON VENTILATION DRAWING


Door Schedule - External						
Ref	Frame Width	Int. Block Opening	Height	Model	P1A - Glazing	PAS 24 - Locking
D01	1005	1045	2100	ED06 M4(2)	Yes	Yes
D02	2475	2485	2100	RD12	Yes	Yes

NOTE: Handle to D02 sidelight to be 1200mm above FFL max.

Door Schedule - Internal				
Ref	Width	Height	Fire Rating	Code
D03	900	2031		ID1
D04	900	2031		ID1
D05	900	2031		ID1

WALL LEGEND

WALL TYPE	SIZE (mm)	STRENGTH (N/mm²)	DENSITY (Kg/m³)	LAMBDA (λ)
BLOCKWORK	100	3.6	600	0.15
40dB STUDWORK	63 (88)	-	-	-

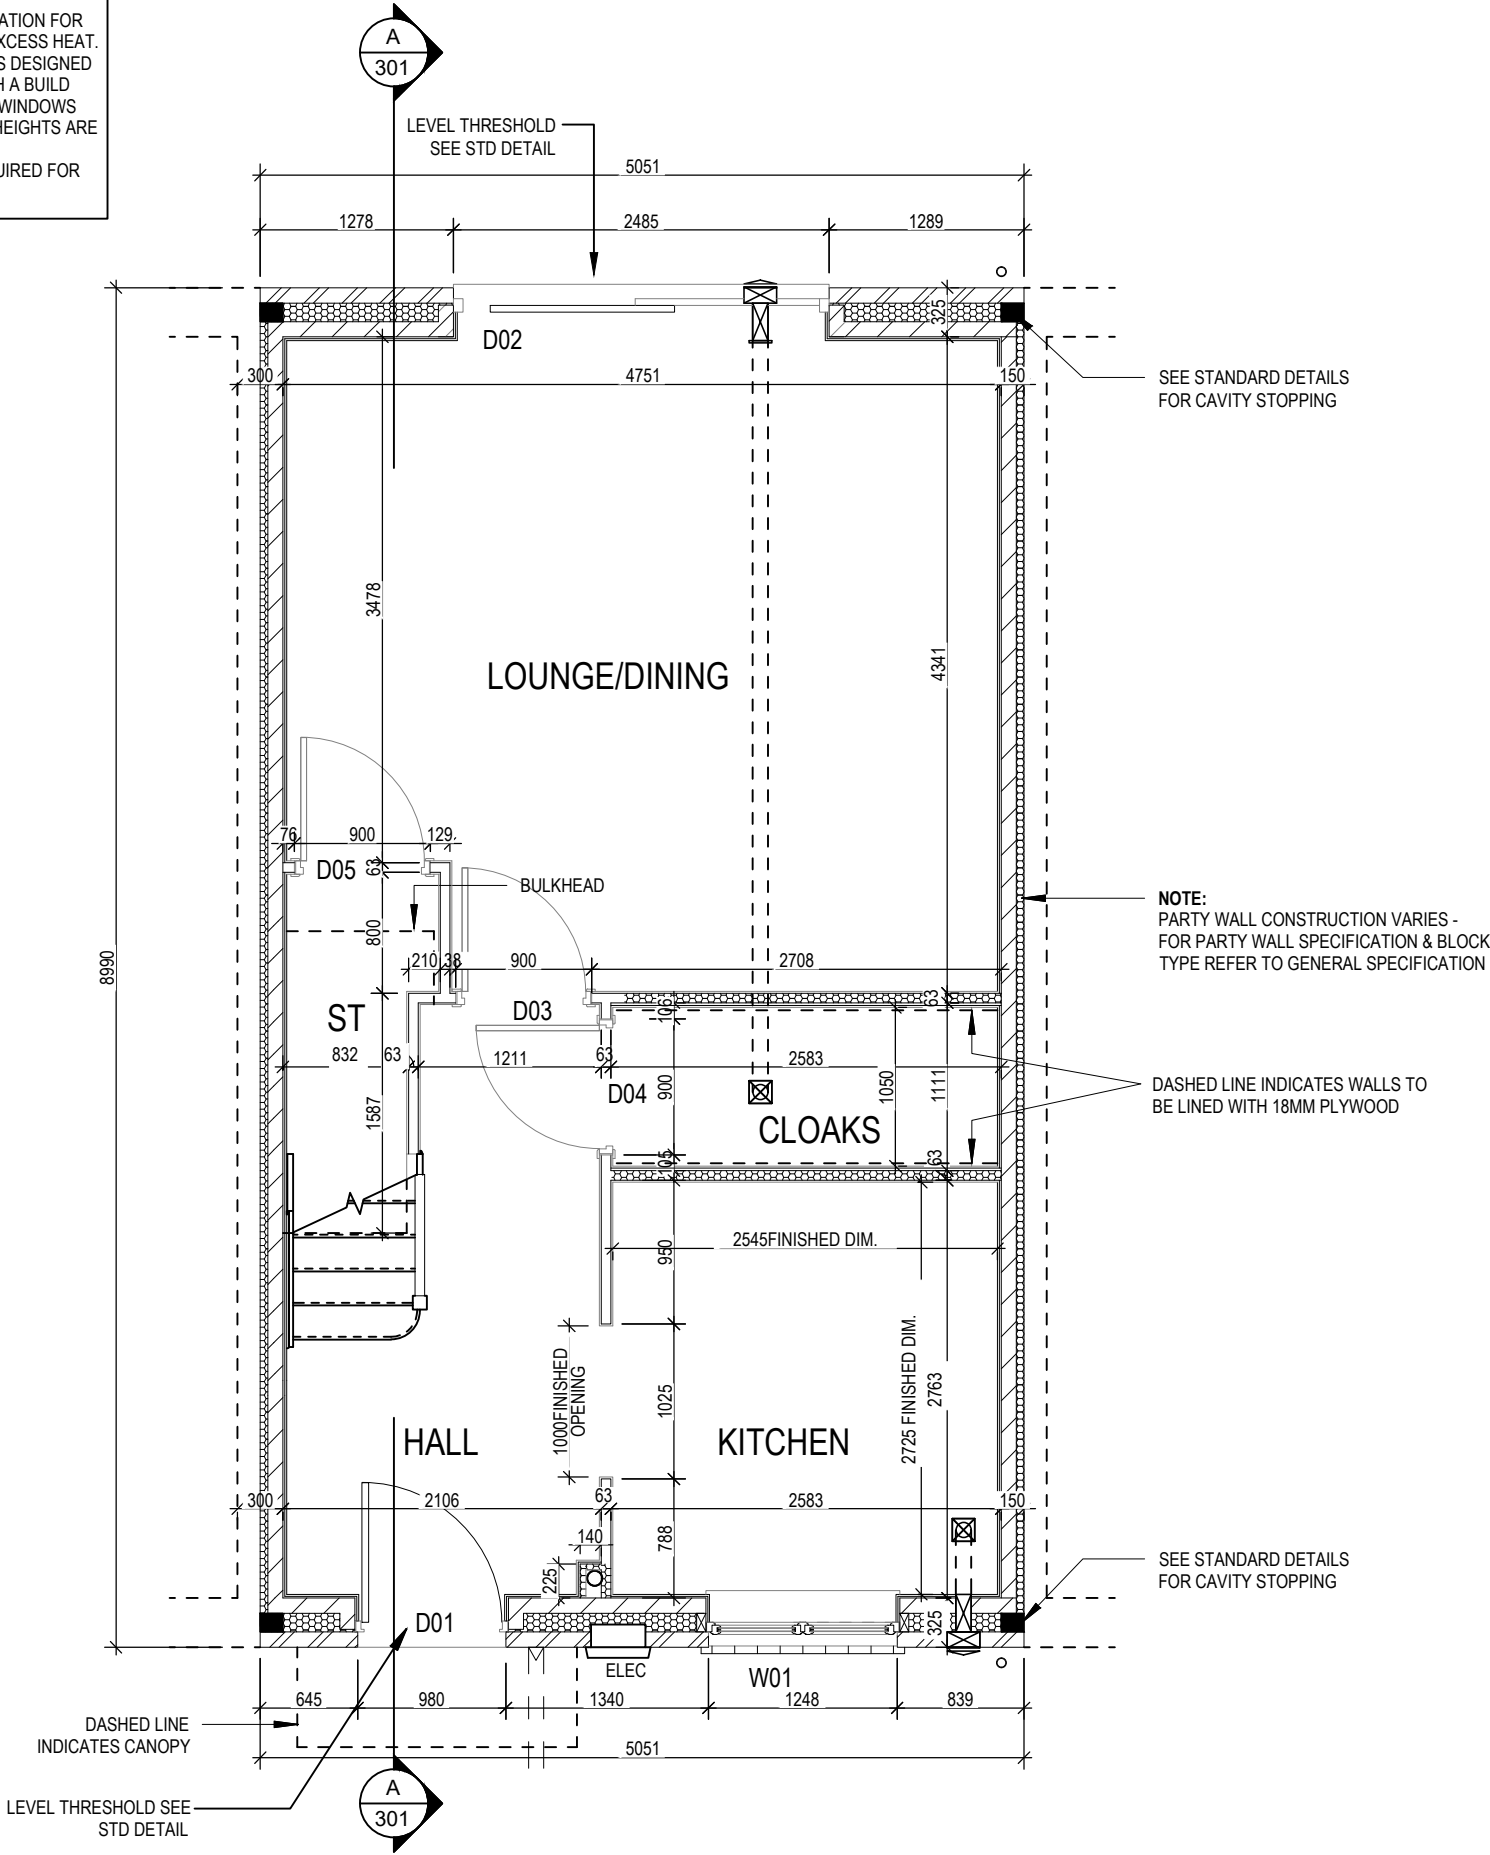

2B4P M4(2)

Mid

G SERIES

Structural Layout
Ground Floor

Dwg No

DCC

Scale

1 : 50

Date

Feb 2023

Dwg Rev

A

A

Level threshold noted to rear door.

12.08.24

Window Schedule						
Ref	Frame Width	Frame Height	Int Block Opening	Comments	P1A - Glazing	PAS 24 - Locking
W02	1273	1040	1283	ESC		
W03	710	890	720	OBS		
W04	1835	1040	1845	ESC		

NOTE: ALL WINDOWS TO BE FITTED WITH OVER-FRAME TRICKLE VENTILATORS. FOR MINIMUM TRICKLE VENTILATION RATES FOR EACH WINDOW WIDTH SEE WINDOW AND DOOR SCHEDULE.

HANDLES - ALL WINDOW HANDLES TO BE FITTED AT A MAXIMUM OF 1400MM ABOVE FFL UNLESS OTHERWISE STATED IN THE COMMENTS COLUMN.

ALL WINDOWS TO BE SAFE CLEAN IN ACCORDANCE WITH B.S. 8213.


WHOLE HOUSE TRICKLE VENTILATION REQUIREMENT STATED ON VENTILATION DRAWING

Door Schedule - Internal				
Ref	Width	Height	Fire Rating	Code
D06	900	2031		ID1
D07	900	2031		ID1
D08	900	2031		ID1
D09	900	2031		ID1
D10	745	2031		ID3

WALL LEGEND

WALL TYPE	SIZE (mm)	STRENGTH (N/mm²)	DENSITY (Kg/m³)	LAMBDA (λ)
BLOCKWORK	100	3.6	600	0.15
40dB STUDWORK	63 (88)	-	-	-

REFER TO TM59 CALCULATION FOR OPENINGS REMOVING EXCESS HEAT. ALL BEDROOM WINDOWS DESIGNED TO 1.1M ABOVE FFL WITH A BUILD TOLERANCE +0/-100MM. WINDOWS WITH LOWER OPENING HEIGHTS ARE EXCLUDED FROM TM59 CALCULATION AND REQUIRED FOR MEANS OF ESCAPE.

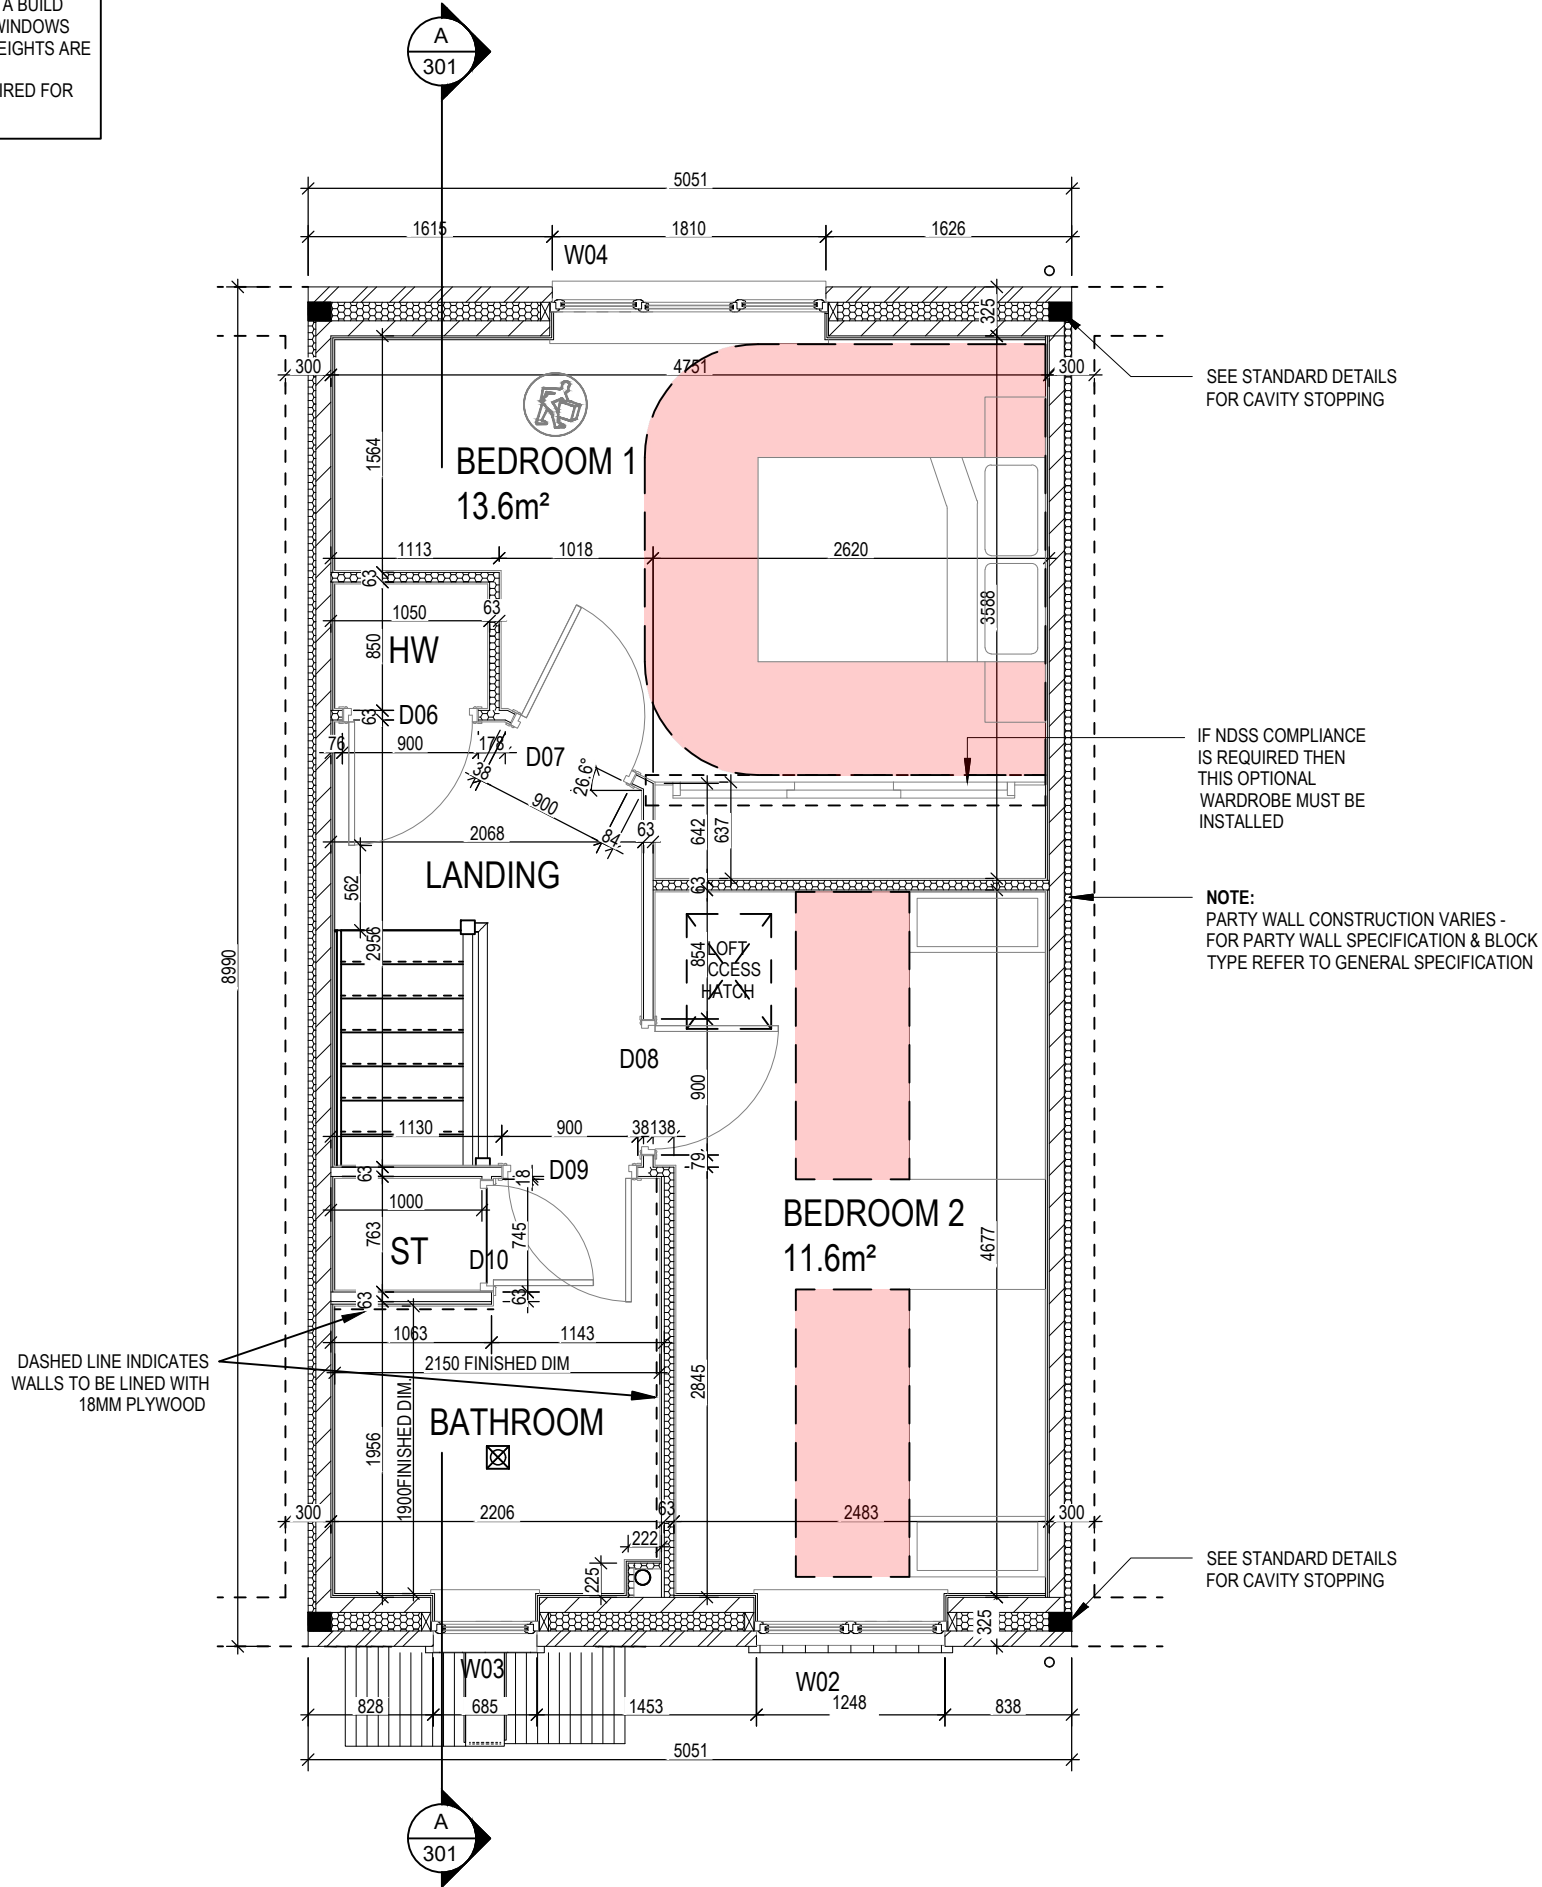

2B4P M4(2)

Mid
G SERIES

Structural Layout
First Floor


Dwg No
202



DCC
2



Scale
1 : 50

Date
Feb 2023

Dwg Rev

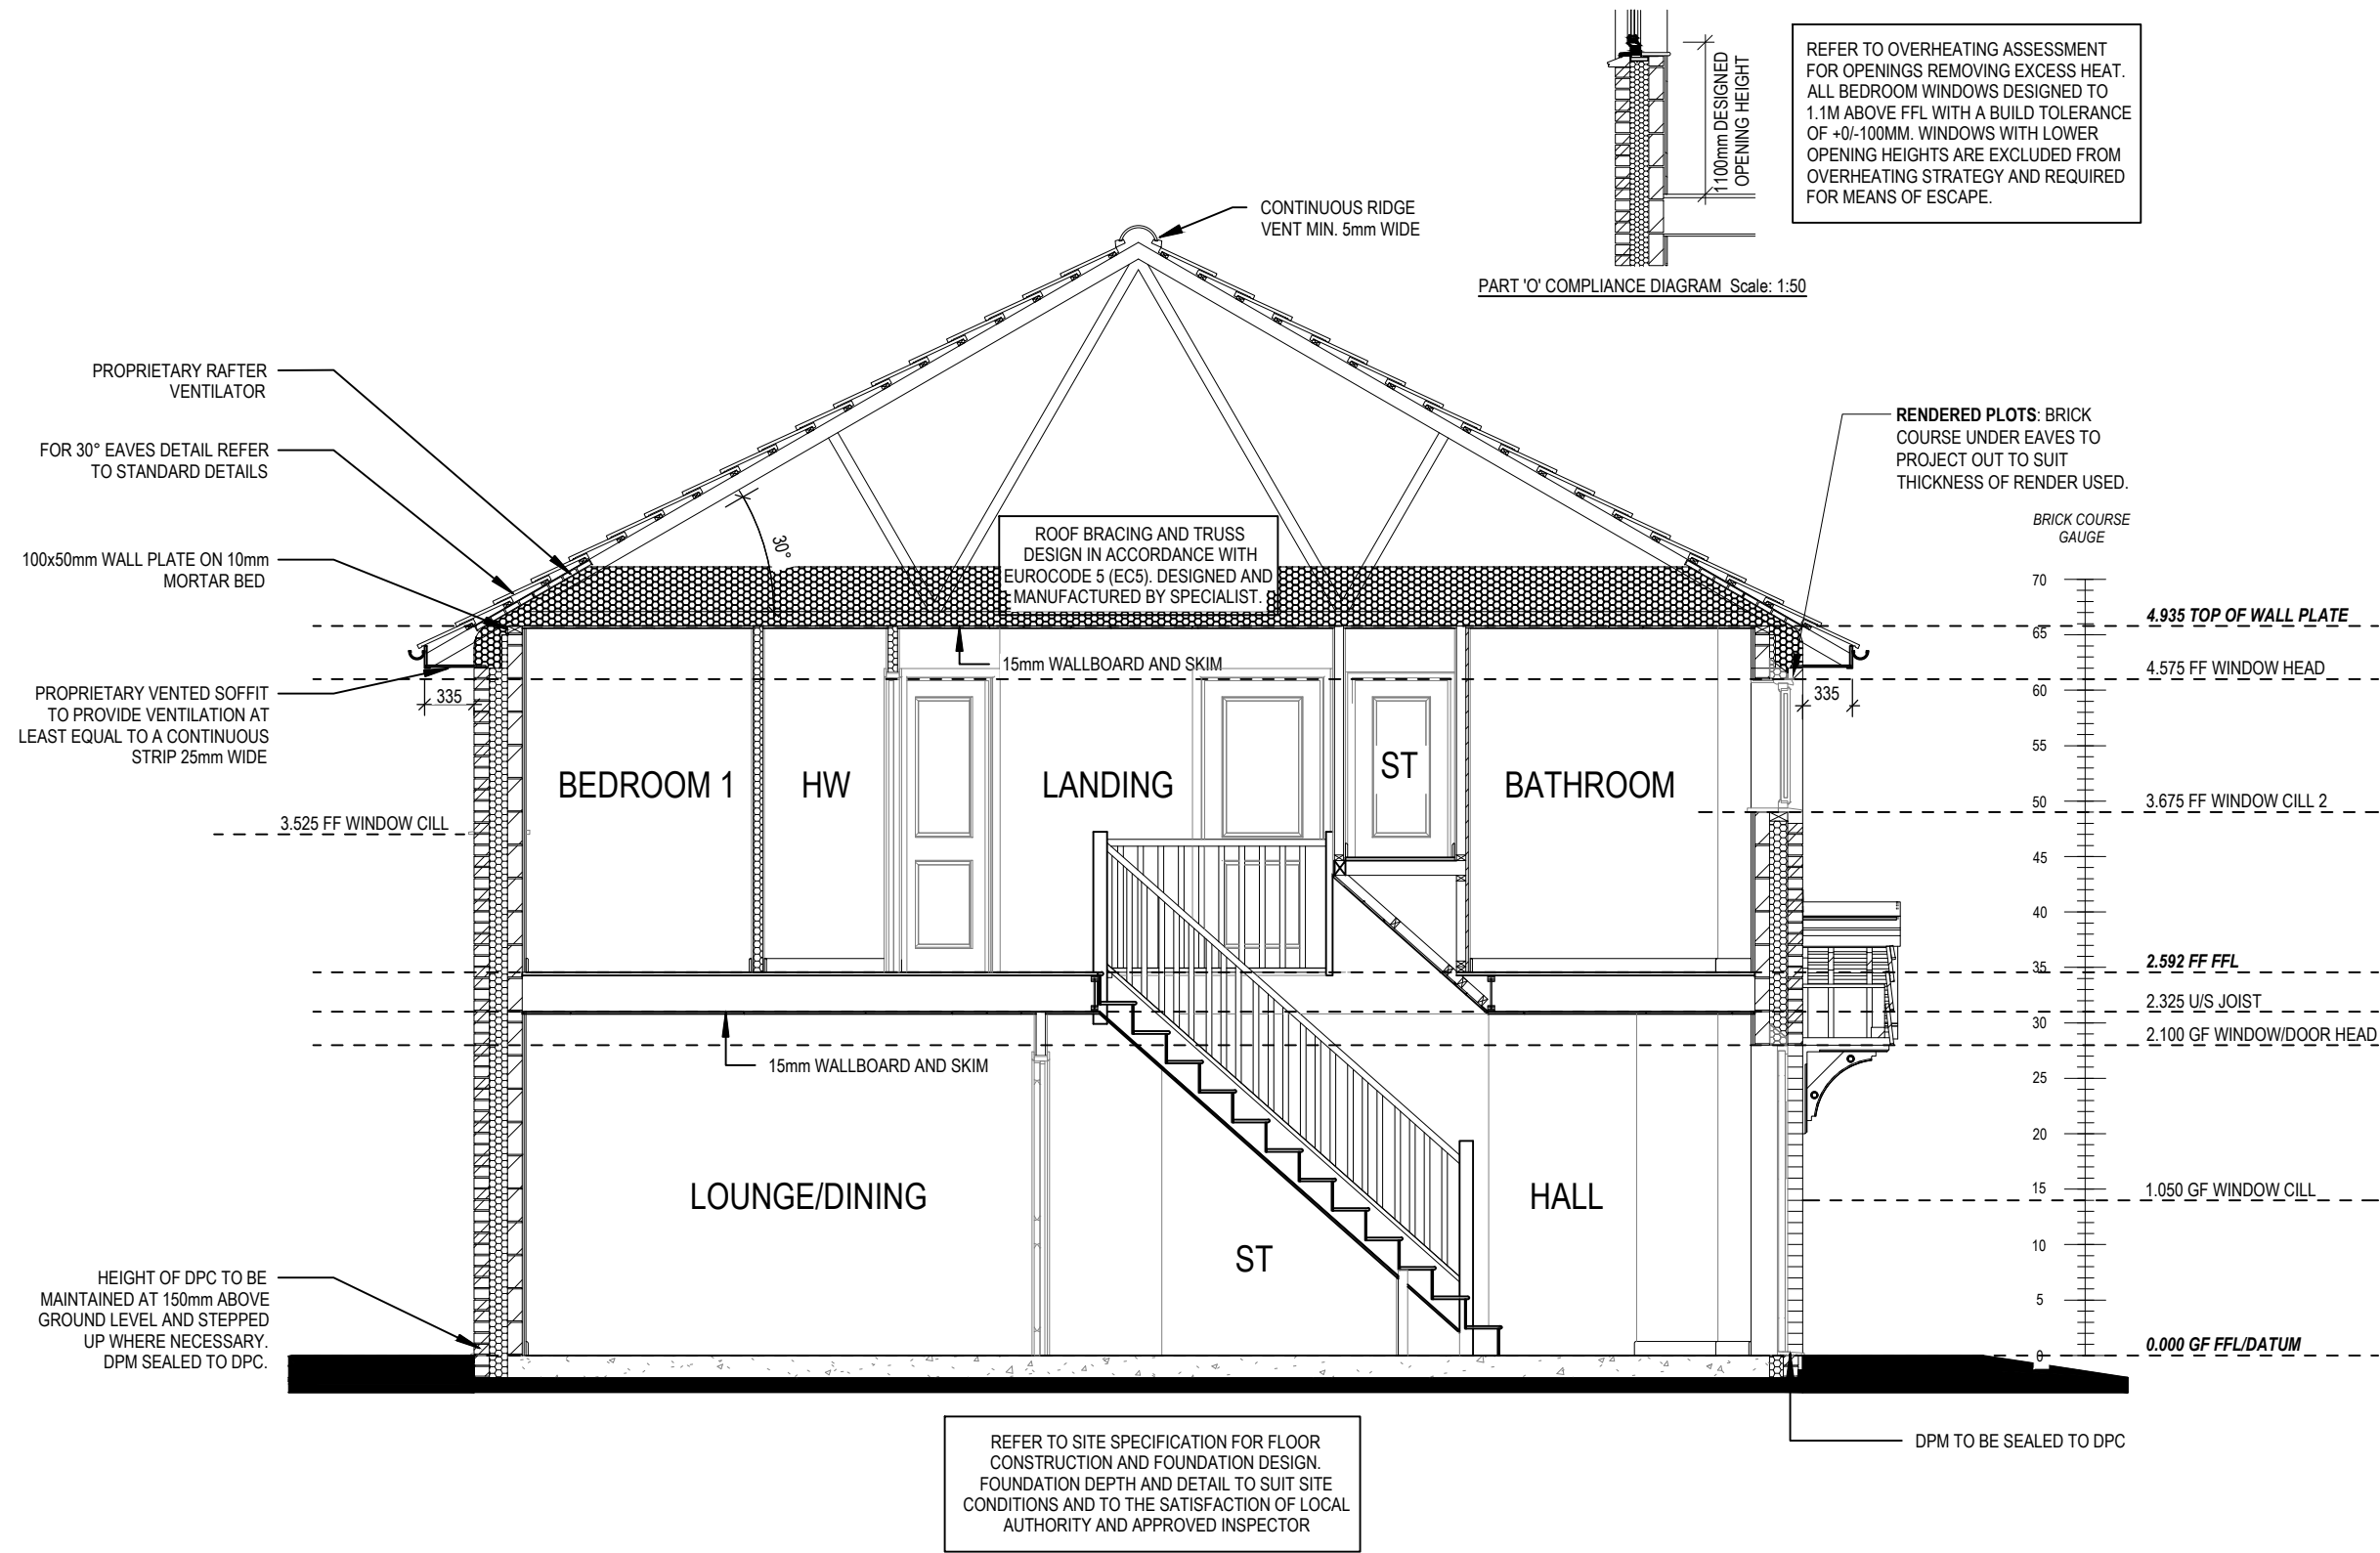

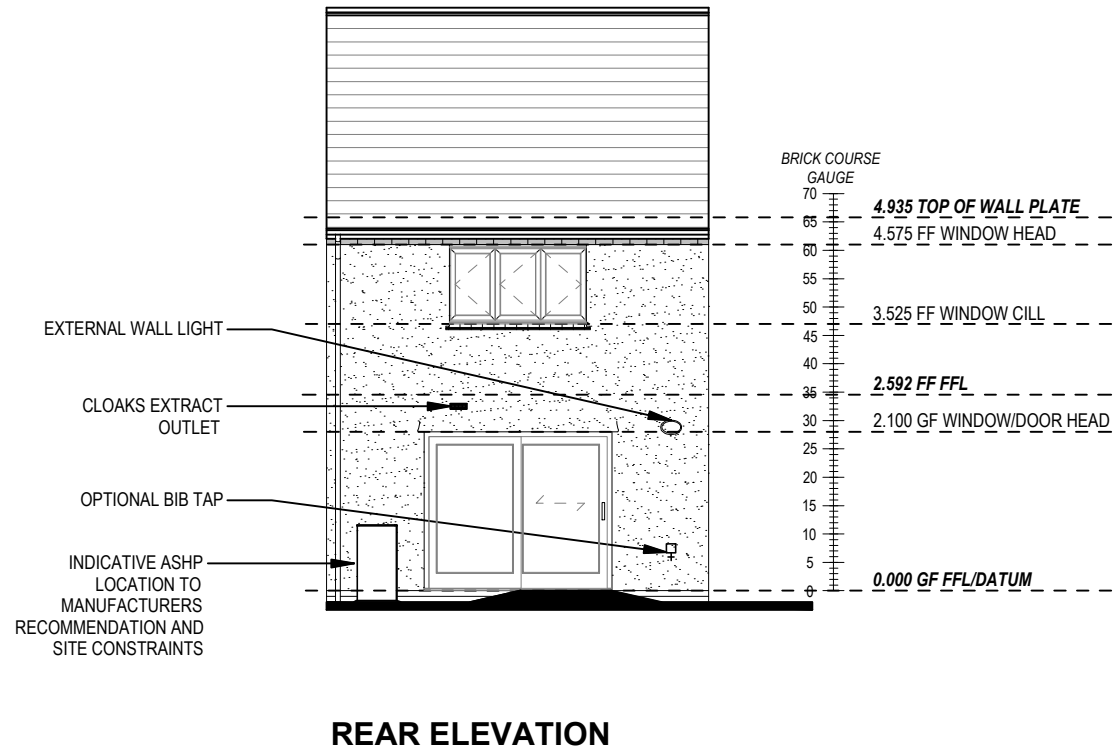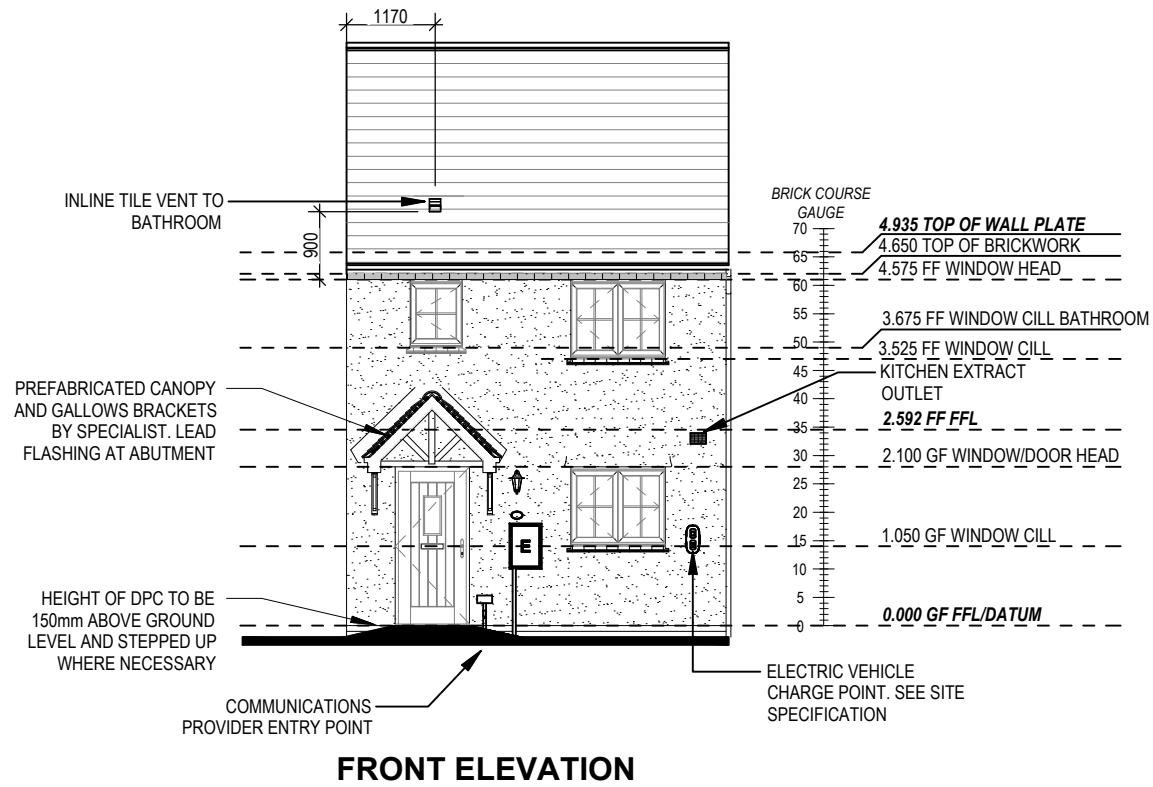

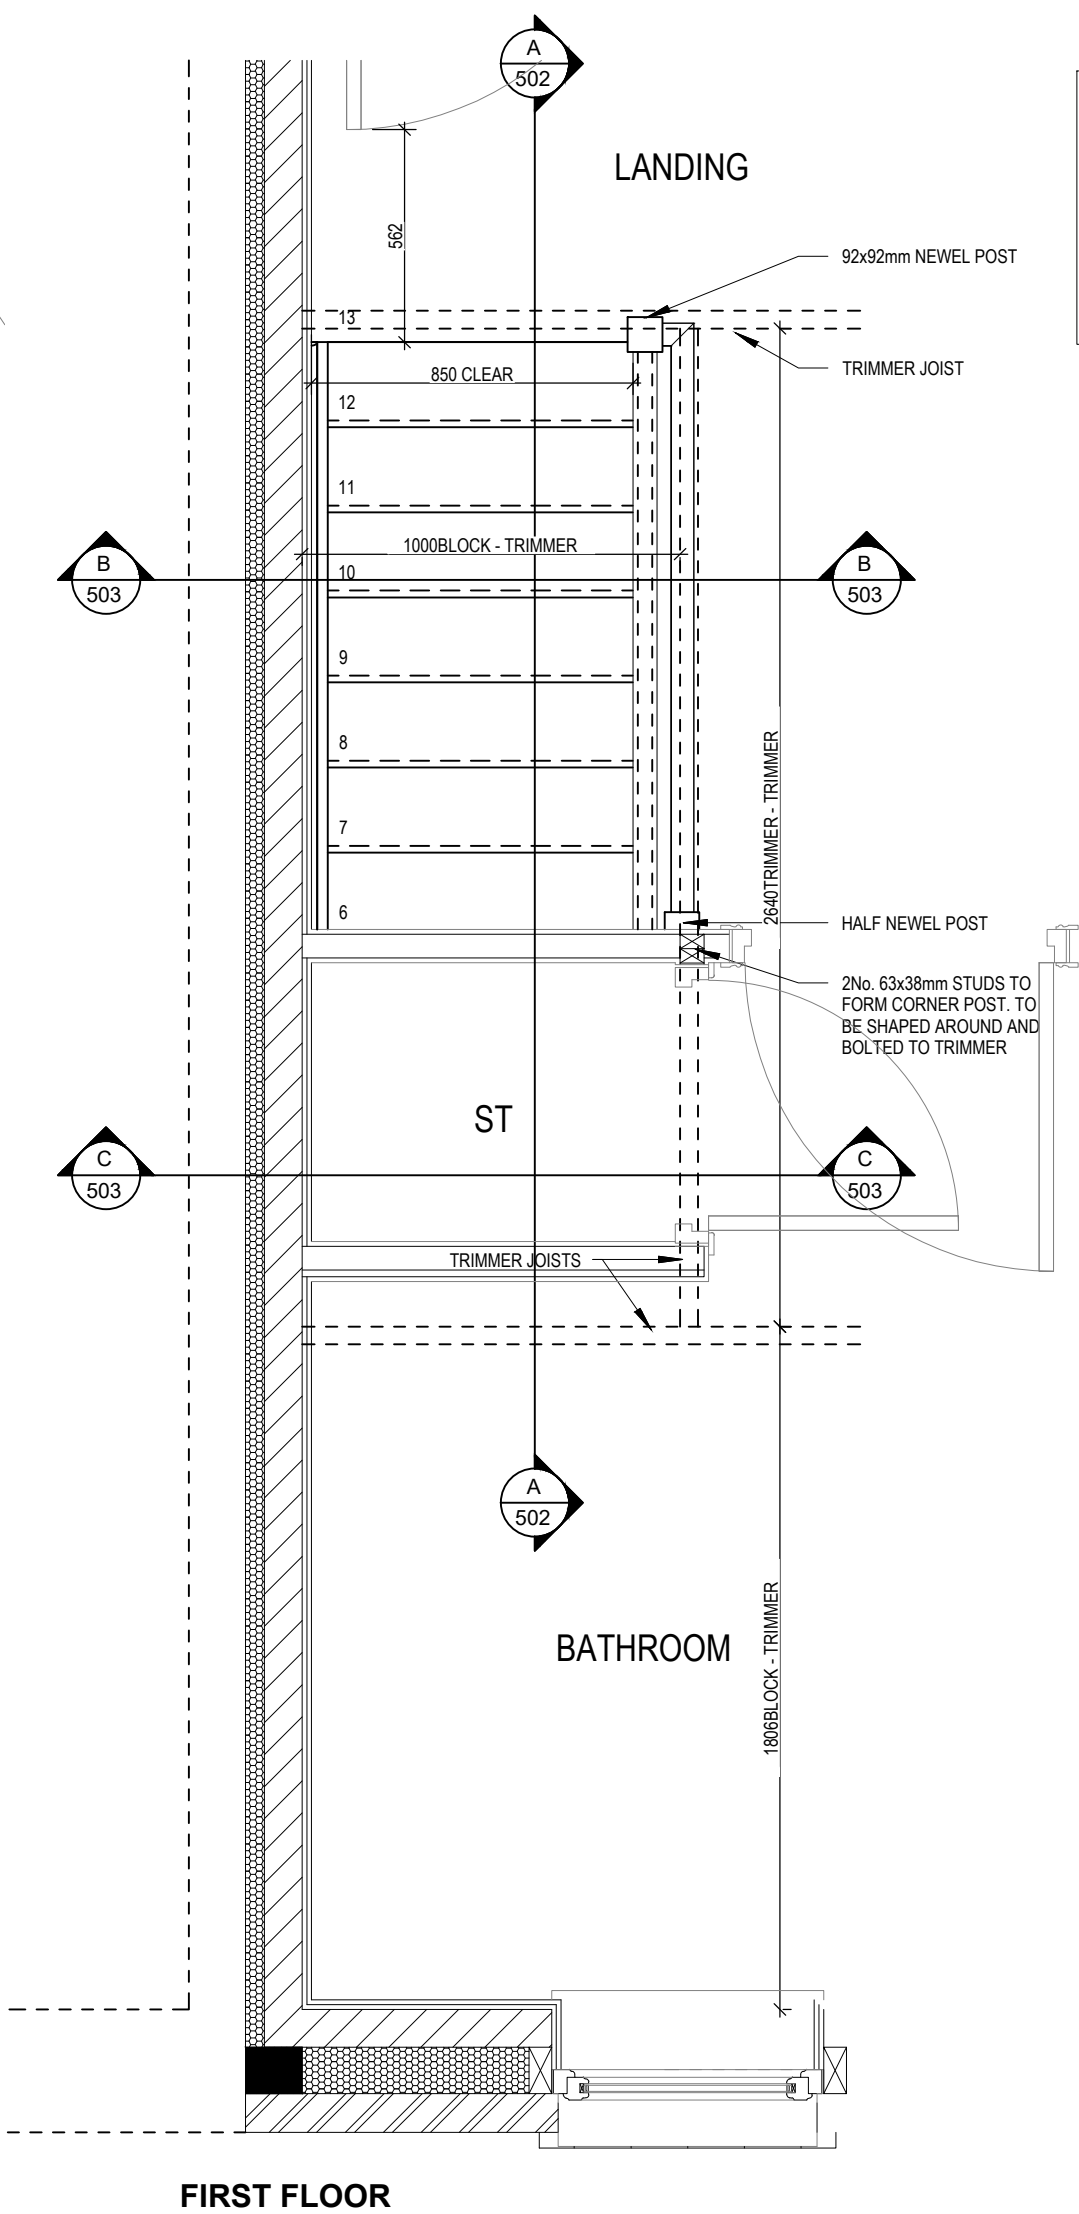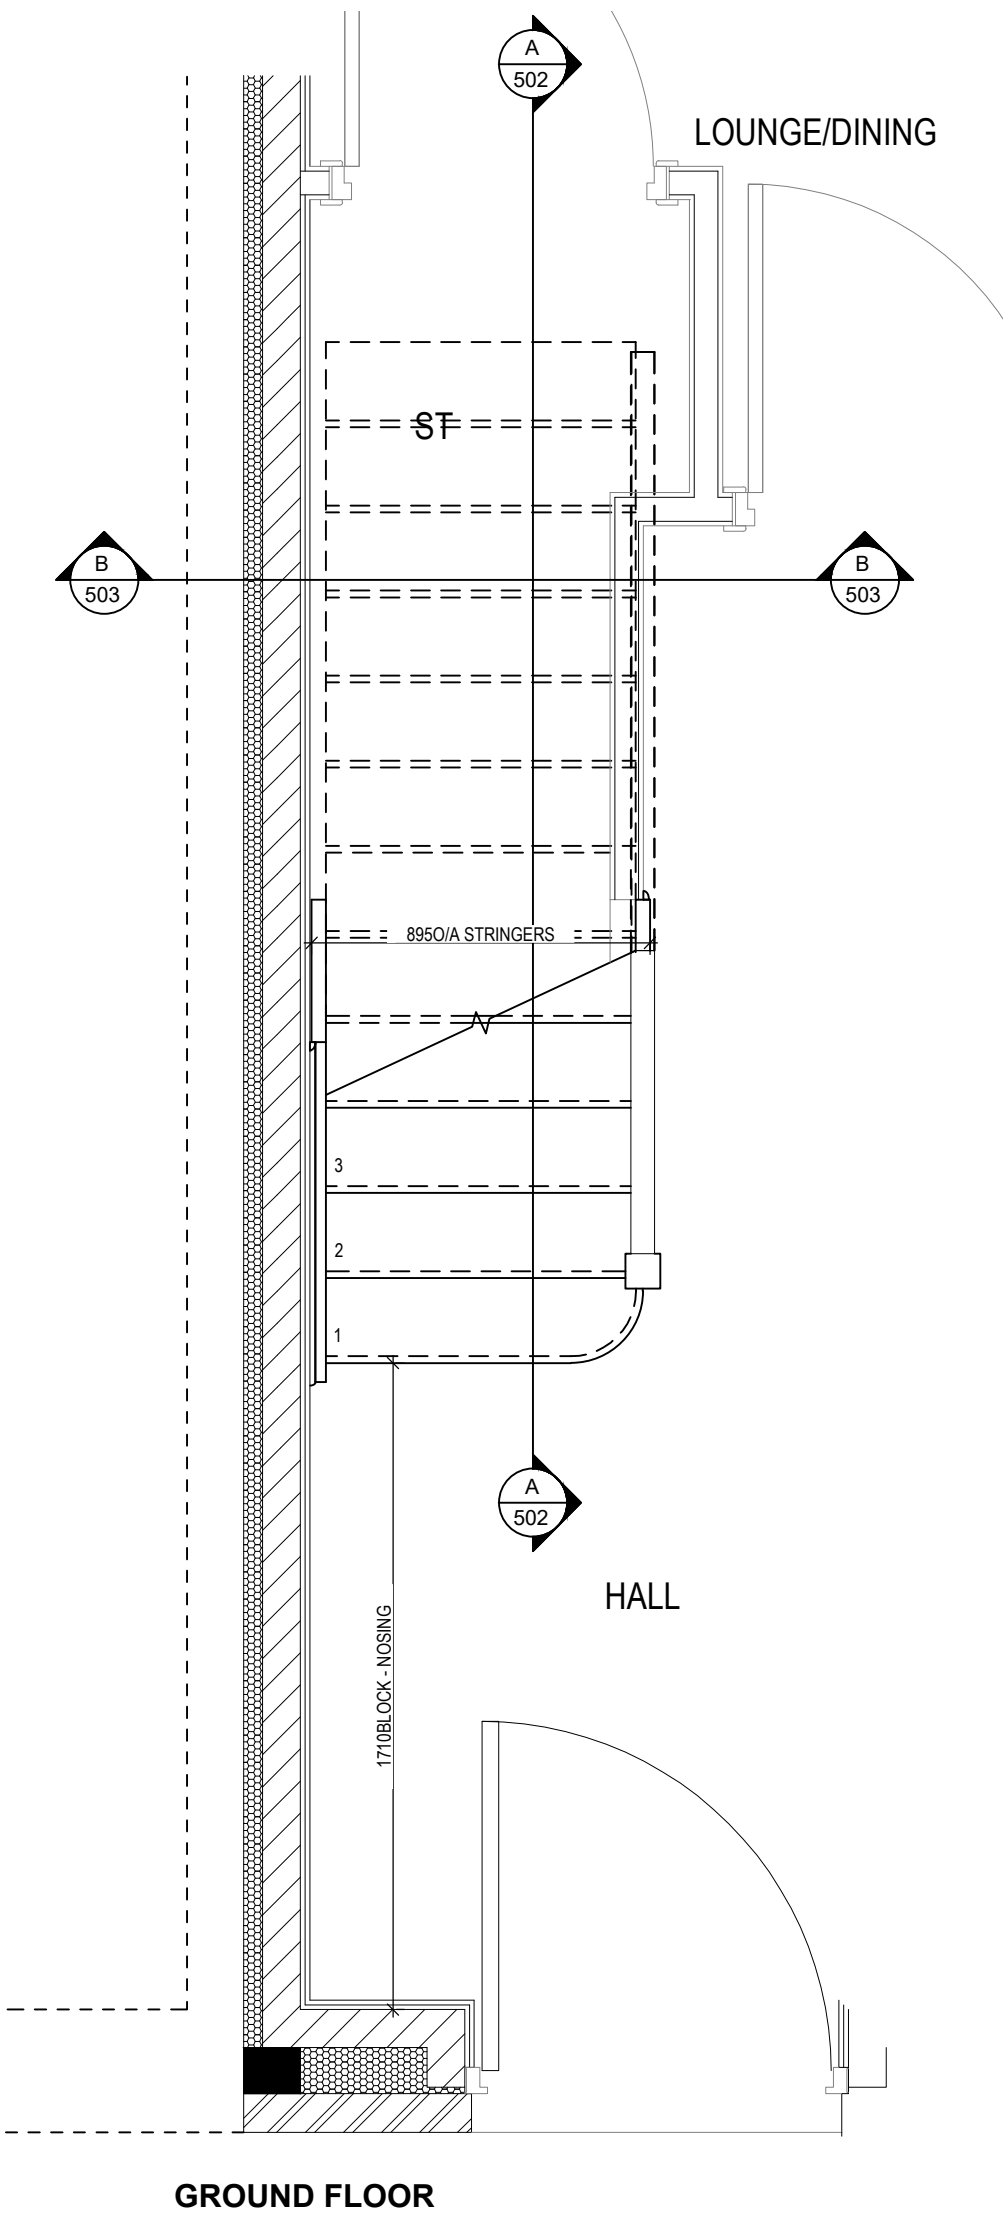


STAIRS SPECIFICATION	
FLOOR - FLOOR	= 2592mm
RISE	= 13No. @ 199.38mm (220mm Max)
GOING	= 225mm (220mm Min)
STRING - STRING	= SEE DWG
PITCH	= 41.55°
STRINGERS	= 32 x 250mm
NEWEL POSTS	= 92 x 92mm
HANDRAIL 900mm ABOVE NOSING LINE	
BALUSTRADE 900mm ABOVE LANDING FLOOR LEVEL	
VERTICAL BALUSTERS 99mm MAX CLEAR BETWEEN EACH	

2B4P M4(2) Mid G SERIES	Staircase Details 1 of 3		
	Scale	DCC	Dwg No
	1 : 20	2	501
Date		Dwg Rev	
Mar 2023			

This drawing must be read in conjunction with relevant Redrow specifications, standard details & structural calculations. All dimension are taken from face of Brick/Block & Studwork. This drawing is subject to copyright law. Do Not Scale Off This Drawing

LOUNGE/DINING

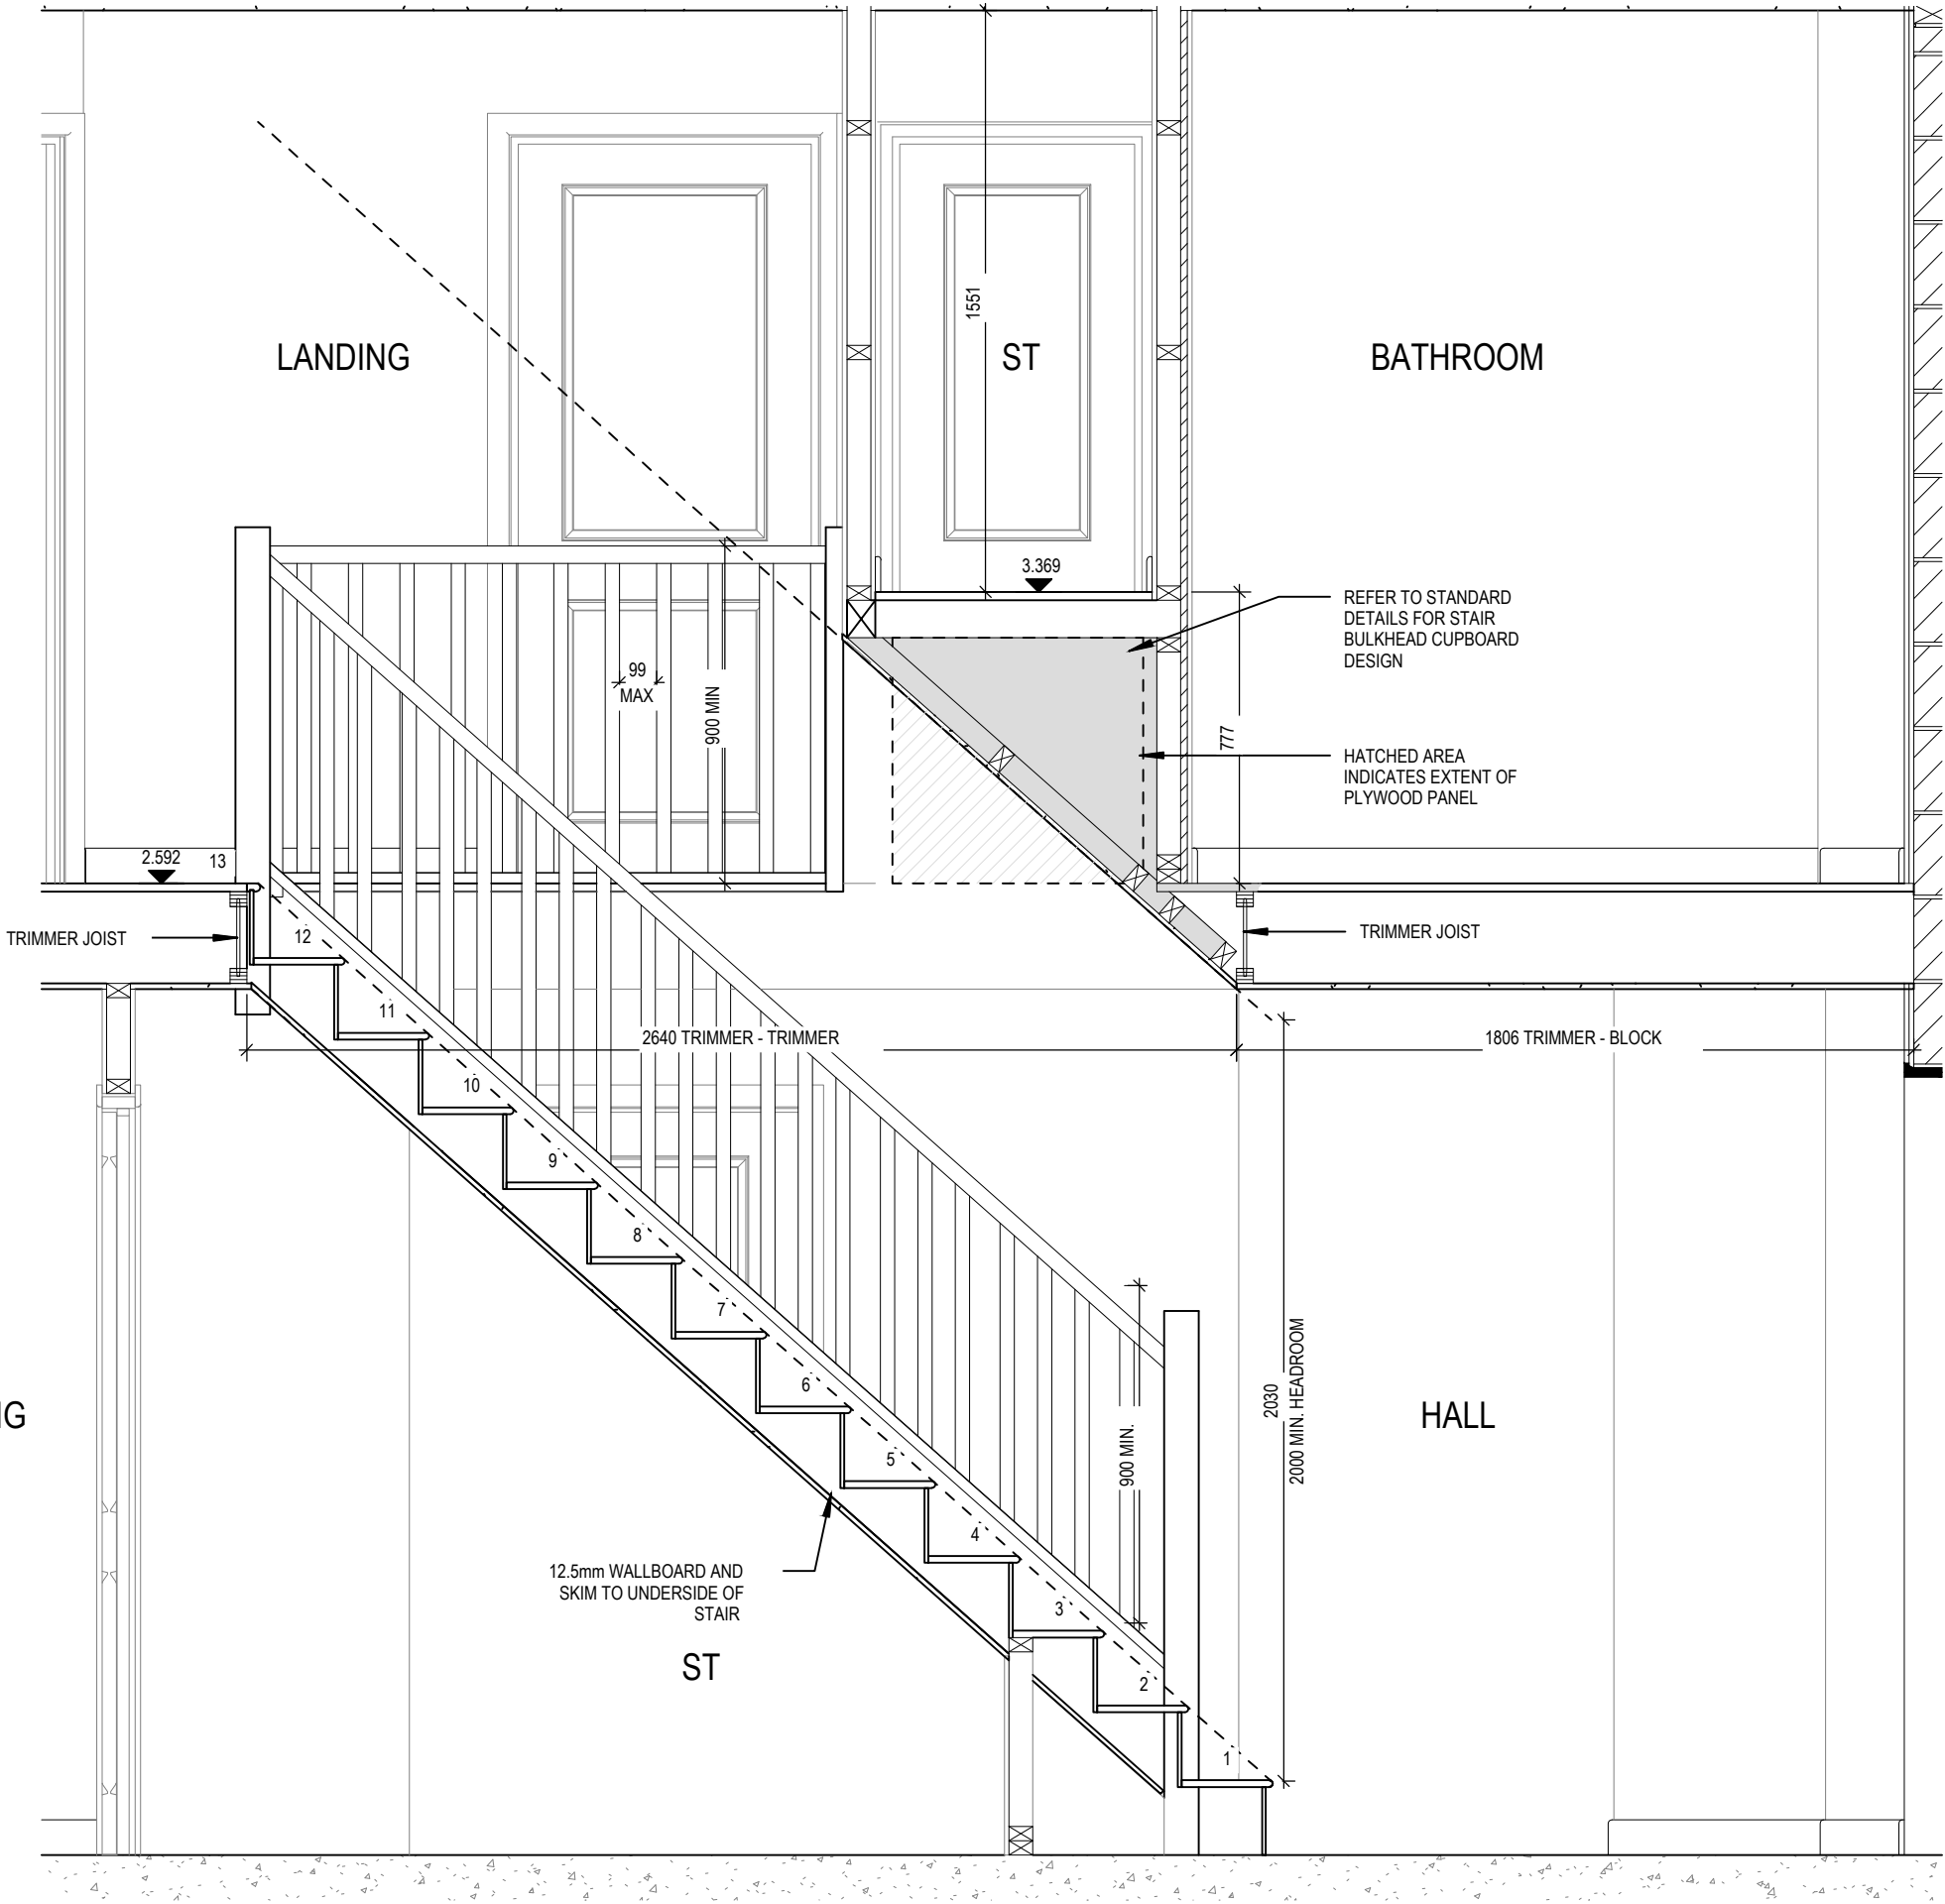


SECTION A-A

2B4P M4(2)


Mid
G SERIES

Staircase Details 2 of 3

Scale
1 : 20
DCC
2
Dwg No
502
Date
Mar 2023
Dwg Rev

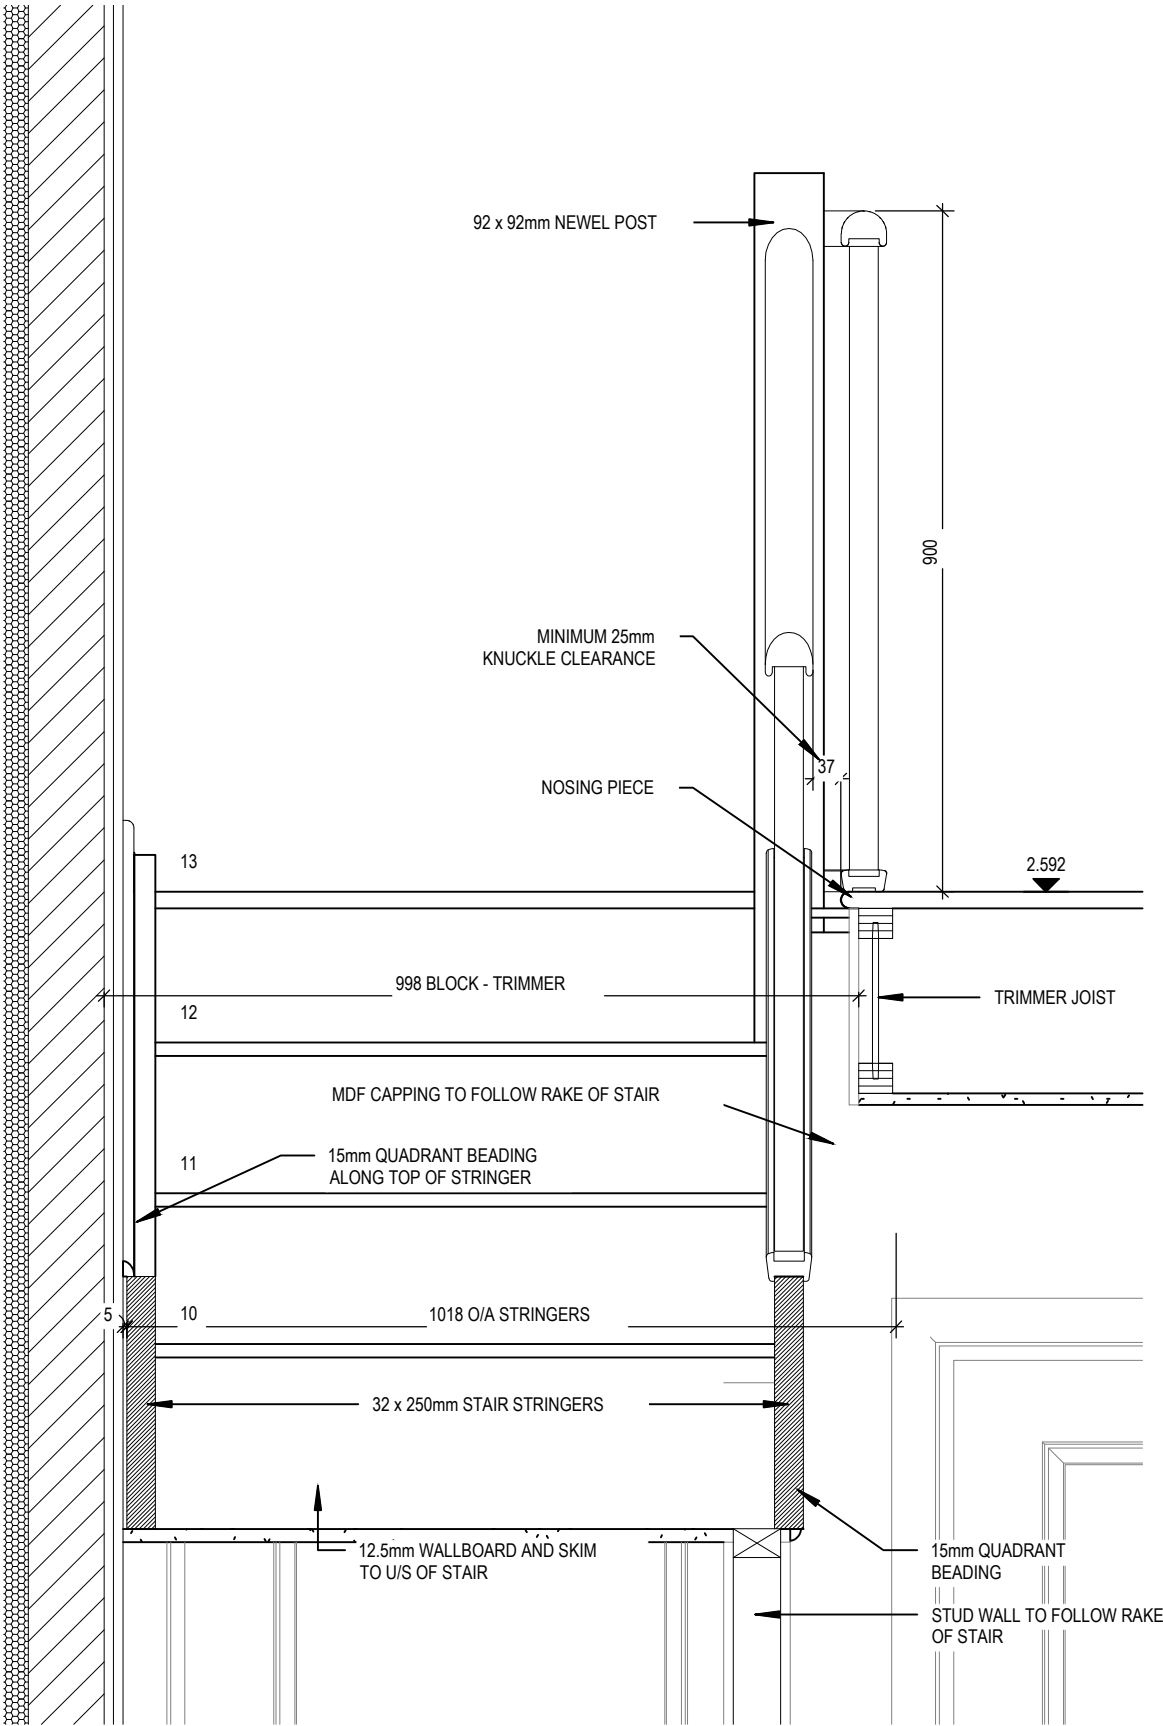

SECTION B-B

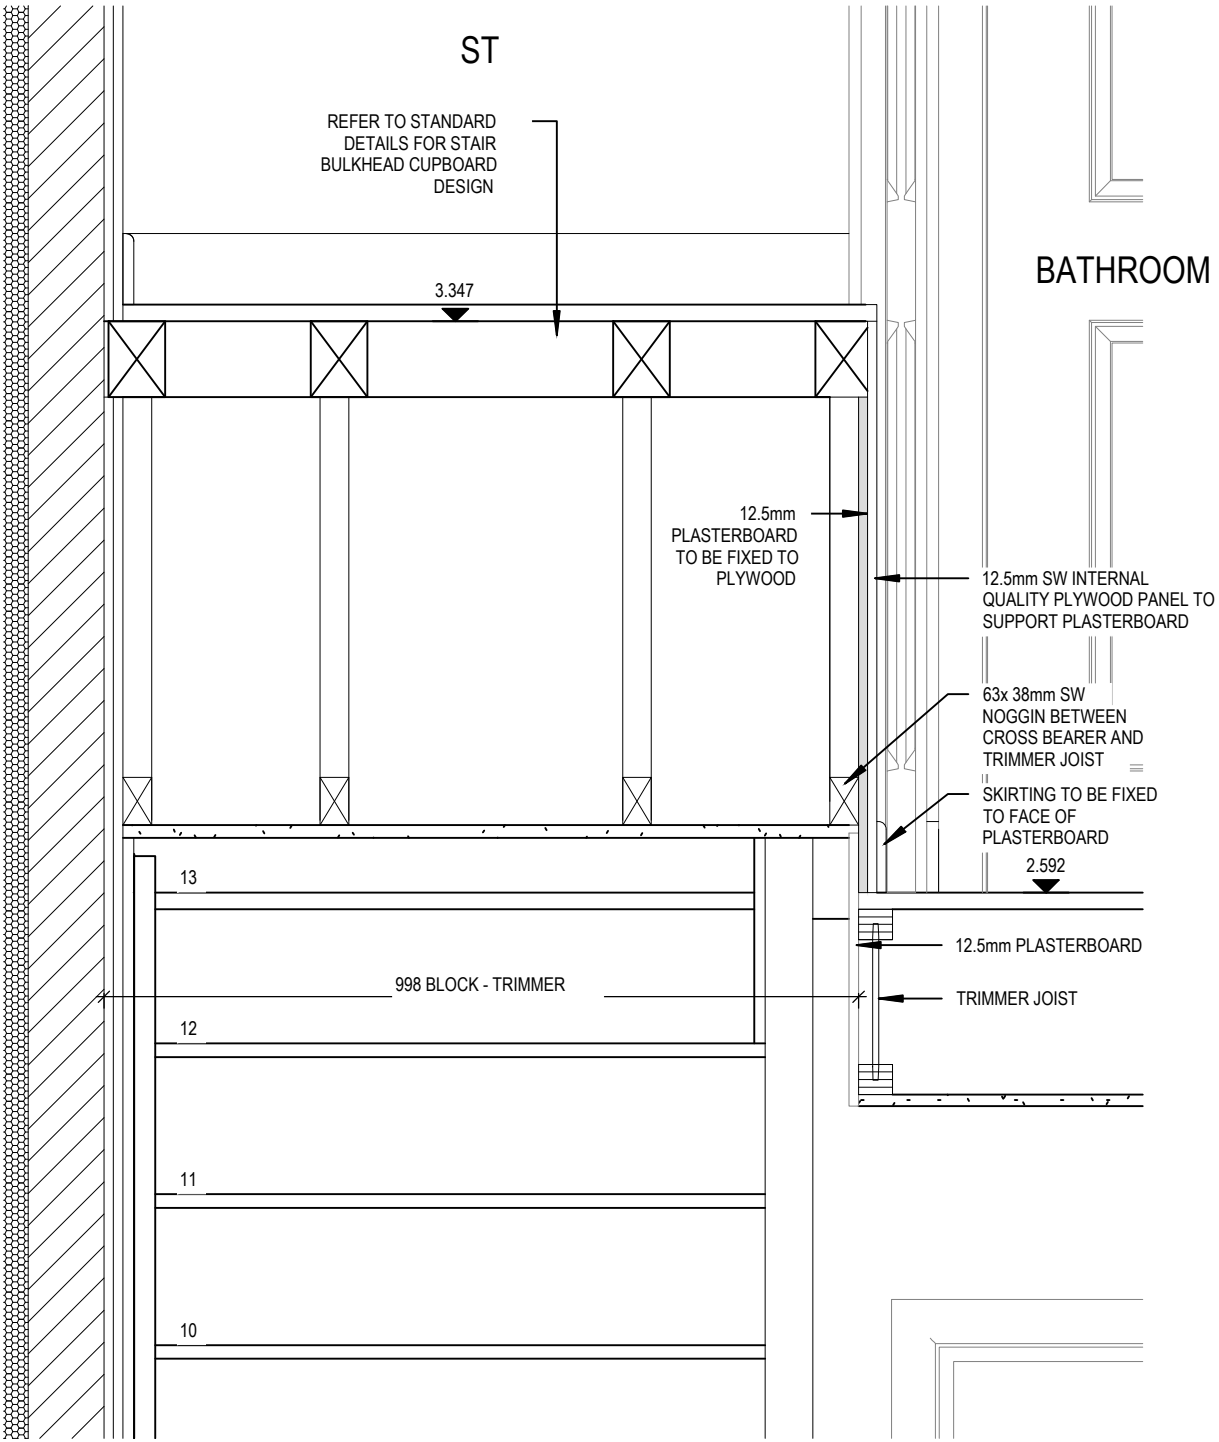

SECTION C-C

2B4P M4(2)

Mid
G SERIES

Staircase Details 3 of 3

Scale
1 : 10


Date
Mar 2023

DCC
2

Dwg No
503

Dwg Rev

	PENDANT TYPE LIGHT FITTING
	BATTEN HOLDER LIGHT FITTING (RENTED PLOTS)
	SINGLE S/W SOCKET OUTLET (LOW LEVEL)
	DOUBLE S/W SOCKET OUTLET (FILLED AT LOW LEVEL, CLEAR AT HIGH LEVEL)
USB	DOUBLE S/W SOCKET OUTLET WITH DOUBLE USB SOCKET (FILLED AT LOW LEVEL, CLEAR AT HIGH LEVEL)
EV	ELECTRIC VEHICLE CHARGE POINT (SEE SITE SPECIFICATION)
EXT	EXTERNAL POWER SUPPLY (OPTIONAL)
	FUSED OUTLET (IMMERSION)
	ISOLATOR SWITCH
	SINGLE SWITCH, DOUBLE SWITCH, TRIPLE SWITCH
	NOTE: WHERE MULTIPLE SWITCHES ARE INDICATED TOGETHER THESE ARE TO BE SWITCHED ON ONE SINGLE PLATE NOT ON MULTIPLE PLATES.
	COMBINED T.V., SATELLITE AND DATA POINT WITH OPTIONAL HIGH LEVEL MOUNT
	T.V. POINT WITH OPTIONAL DATA POINT AND OPTIONAL HIGH LEVEL MOUNT
	OPTIONAL T.V. POINT WITH OPTIONAL DATA POINT AND OPTIONAL HIGH LEVEL MOUNT
	DATA POINT
	SMOKE DETECTOR
	HEAT DETECTOR
	SHAVER SOCKET
	ROOM THERMOSTAT
	INDIVIDUAL ZONE THERMOSTAT
	2 ZONE PROGRAMMER AND HOT WATER TIMER
	PROGRAMMABLE THERMOSTAT
	EXTERNAL WALL LIGHT FITTING WITH INTEGRAL DUSK TO DAWN SENSOR
	EXTERNAL SURFACE MOUNTED BULKHEAD LIGHT FITTING TO CANOPY
	DOOR BELL PUSH BUTTON IN FRAME
	PV METER SWITCH (SITE UPGRADE/CUSTOMER OPTION)
	SEMI RECESSED CONSUMER UNIT
	DUSK TO DAWN SENSOR
	COMMS ENTRY POINT WITH SLOW RADIUS BEND
	COMBINATION WALL MOUNTED ELECTRICAL DEVICES (REFER TO STD DETAIL), CONSISTING: - DOOR BELL CHIME - ALARM KEYPAD (CUSTOMER OPTION) - TRIPLE LIGHT SWITCH
	BANK OF SWITCHES
	PASSIVE INFRA-RED DETECTOR TO BE FITTED 2.4m MAX ABOVE FFL (CUSTOMER OPTION)
	CENTRAL PROCESSOR UNIT, HEIGHT TO UNDERSIDE 2100mm (CUSTOMER OPTION)
	DOOR CONTACT (CUSTOMER OPTION)

 

This drawing must be read in conjunction with relevant Redrow specifications, standard details & structural calculations. All dimension are taken from face of Brick/Block & Studwork. This drawing is subject to copyright law. Do Not Scale Off This Drawing

ELECTRICAL LEGEND


-  PENDANT TYPE LIGHT FITTING
-  BATTEN HOLDER LIGHT FITTING
-  SINGLE S/W SOCKET OUTLET (LOW LEVEL)
-  DOUBLE S/W SOCKET OUTLET (FILLED AT LOW LEVEL, CLEAR AT HIGH LEVEL)
- USB

USB
- DOUBLE S/W SOCKET OUTLET WITH DOUBLE USB SOCKET (FILLED AT LOW LEVEL, CLEAR AT HIGH LEVEL)
- EV
- ELECTRIC VEHICLE CHARGE POINT (SEE SITE SPECIFICATION)
- EXT
- EXTERNAL POWER SUPPLY (OPTIONAL)
- 
- FUSED OUTLET (IMMERSION)
- 
- ISOLATOR SWITCH
- 




- NOTE: WHERE MULTIPLE SWITCHES ARE INDICATED TOGETHER THESE ARE TO BE SWITCHED ON ONE SINGLE PLATE NOT ON MULTIPLE PLATES.
- 
- COMBINED T.V., SATELLITE AND DATA POINT WITH OPTIONAL HIGH LEVEL MOUNT
- 
- T.V. POINT WITH OPTIONAL DATA POINT AND OPTIONAL HIGH LEVEL MOUNT
- 
- OPTIONAL T.V. POINT WITH OPTIONAL DATA POINT AND OPTIONAL HIGH LEVEL MOUNT
- 
- DATA POINT
- 
- SMOKE DETECTOR
- 
- HEAT DETECTOR
- 
- SHAVER SOCKET
- 
- ROOM THERMOSTAT
- 
- INDIVIDUAL ZONE THERMOSTAT
- 
- 2 ZONE PROGRAMMER AND HOT WATER TIMER
- 
- PROGRAMMABLE THERMOSTAT
- 
- EXTERNAL WALL LIGHT FITTING WITH INTEGRAL DUSK TO DAWN SENSOR
- 
- EXTERNAL SURFACE MOUNTED BULKHEAD LIGHT FITTING TO CANOPY
- 
- DOOR BELL PUSH BUTTON IN FRAME
- 
- PV METER SWITCH (SITE UPGRADE/CUSTOMER OPTION)
- 
- SEMI RECESSED CONSUMER UNIT
- 
- DUSK TO DAWN SENSOR
- 
- COMMS ENTRY POINT WITH SLOW RADIUS BEND
- 
- COMBINATION WALL MOUNTED ELECTRICAL DEVICES (REFER TO STD DETAIL).
CONSISTING:

- DOOR BELL CHIME
- ALARM KEYPAD (CUSTOMER OPTION)
- TRIPLE LIGHT SWITCH
- 
- BANK OF SWITCHES
- 
- PASSIVE INFRA-RED DETECTOR TO BE FITTED 2.4m MAX ABOVE FFL (CUSTOMER OPTION)
- 
- CPU
CENTRAL PROCESSOR UNIT, HEIGHT TO UNDERSIDE 2100mm (CUSTOMER OPTION)
- 
- DC
DOOR CONTACT (CUSTOMER OPTION)

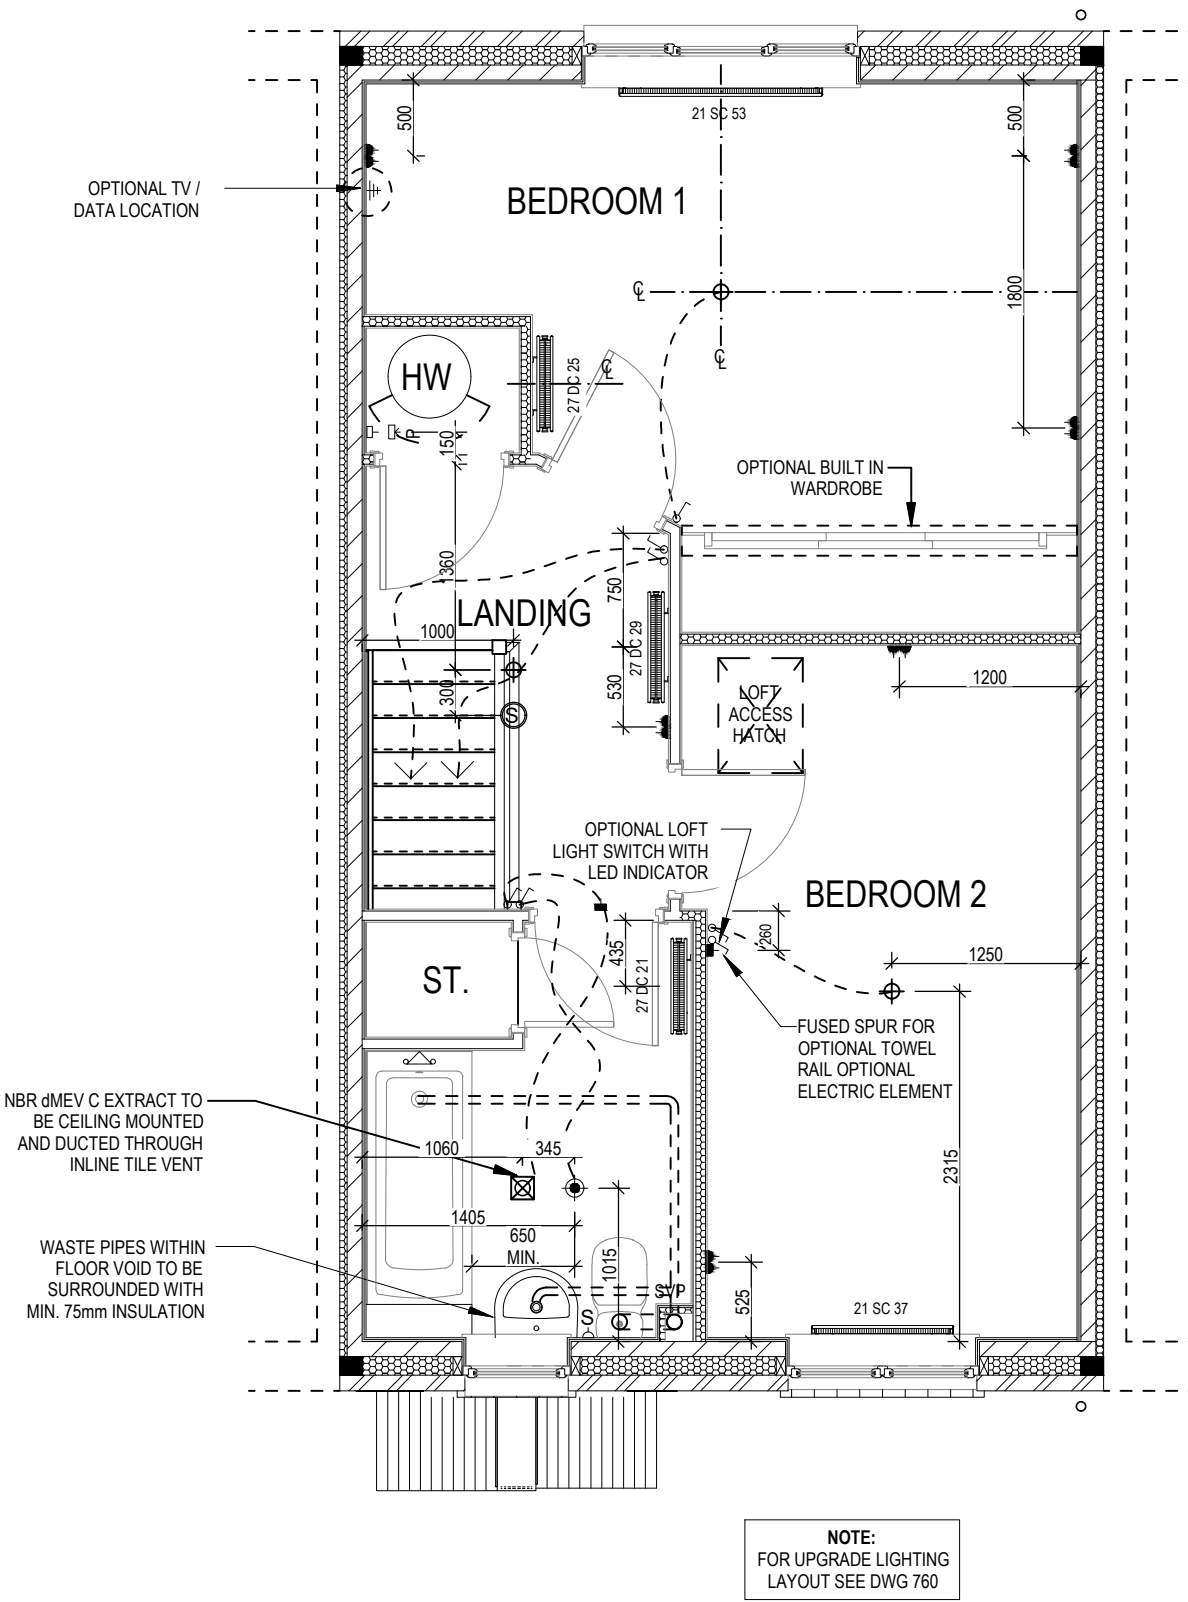


2B4P M4(2)	Services Layout First Floor		DCC	Dwg No	A
				602	
				Dwg Rev	
Mid G SERIES			Scale	Mar 2023	
			1 : 50		
			Date		
			System 3 extracts indicated. Rads amended to suit Group update to Tavy.		05.04.24
			A		

ELECTRICAL LEGEND

-  FUSED OUTLET (IMMERSION)
-  ISOLATOR SWITCH
- UFH


 OPTIONAL ELECTRIC UNDER FLOOR HEATING WITH CONTROLLER AND STAT
-  SINGLE SWITCH
-  DOUBLE SWITCH
-  TRIPLE SWITCH
- NOTE: WHERE MULTIPLE SWITCHES ARE INDICATED TOGETHER THESE ARE TO BE SWITCHED ON ONE SINGLE PLATE NOT ON MULTIPLE PLATES.
-  SHAVER SOCKET

 OPTIONAL DIGITAL SHOWER SWITCH

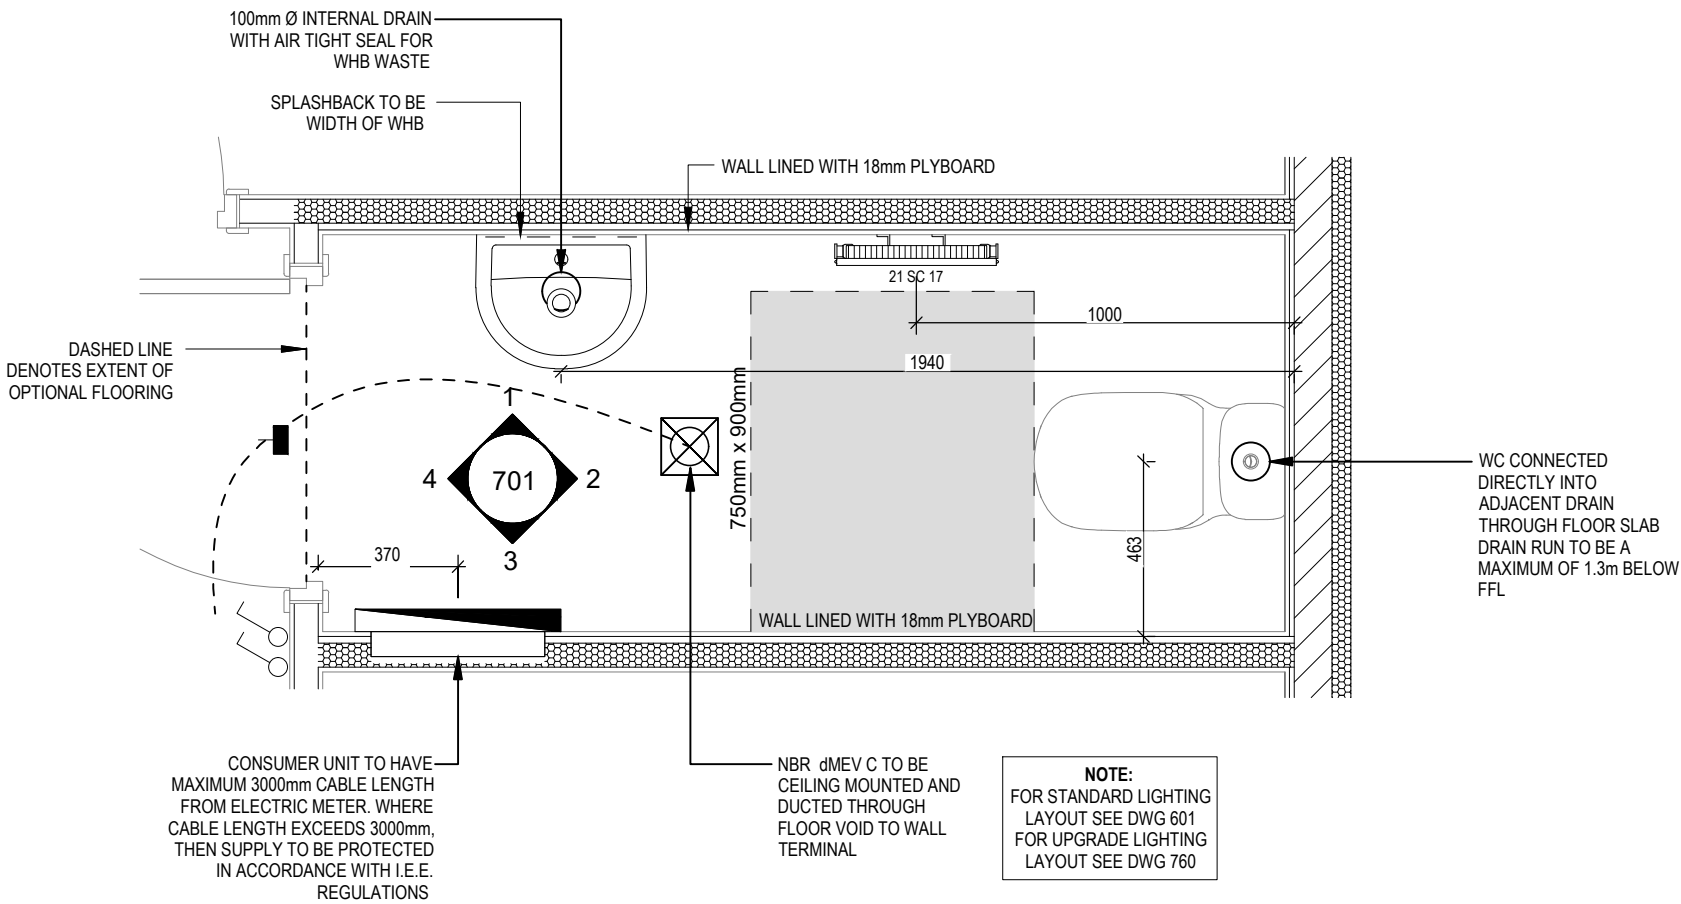

CLOAKS LAYOUT

Scale: 1 : 20

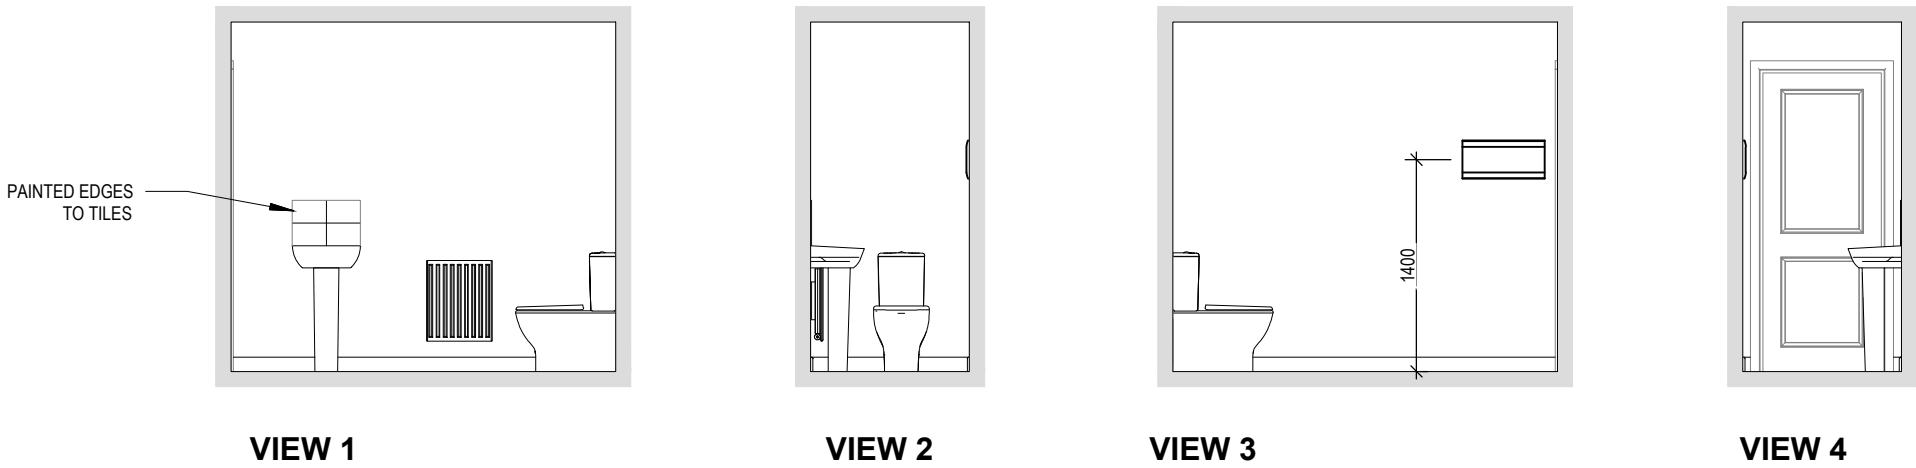


Scale: 1 : 50

2B4P M4(2)	Cloaks Details		Scale	DCC	Dwg No	05.04.24
			As indicated	2	701	
Mid G SERIES			Date		Dwg Rev	A
			Mar 2023			

	FUSED OUTLET (IMMERSION)
	ISOLATOR SWITCH
UFH	OPTIONAL ELECTRIC UNDER FLOOR HEATING WITH
	CONTROLLER AND STAT
	SINGLE SWITCH
	DOUBLE SWITCH
	TRIPLE SWITCH

SHAVESOCKET

OPTIONAL DIGITAL SHOWER SWITCH

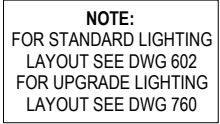

Scale: 1 : 20



- ELECTRICAL LEGEND

PELMET LIGHT FITTING

FUSED OUTLET (IMMERSION)

ISOLATOR SWITCH

SINGLE SWITCH

DOUBLE SWITCH

TRIPLE SWITCH

NOTE: WHERE MULTIPLE SWITCHES ARE INDICATED TOGETHER THESE ARE TO BE SWITCHED ON ONE SINGLE PLATE NOT ON MULTIPLE PLATES.

BANK OF SWITCHES TO ISOLATE HOB, EXTRACTOR HOOD, WASHING MACHINE, DISHWASHER, TUMBLE DRYER, FRIDGE/FREEZER, MICROWAVE OVEN, OPTIONAL WATER HEATER WITH NEON INDICATOR, ALL IN ACCORDANCE WITH THE APPLIANCE/SPACE PROVIDED ON LAYOUT.

UNSWITCHED SOCKET / FUSED SPUR, TO BE CEILING MOUNTED, SEE STANDARD DETAILS

SINGLE UNSWITCHED SOCKET (HIGH LEVEL)

SINGLE UNSWITCHED SOCKET (LOW LEVEL)

SINGLE UNSWITCHED FUSED SPUR (LOW LEVEL)

DOUBLE S/W SOCKET OUTLET (HIGH LEVEL)

DOUBLE S/W SOCKET OUTLET (LOW LEVEL)

HEAT DETECTOR TO BS EN 14604: 2005, TO BE PERMANENTLY WIRED TO A SEPARATELY FUSED CIRCUIT AT THE DISTRIBUTION BOARD. WHERE MORE THAN ONE ARE INSTALLED THEY WILL BE INTER-CONNECTED. WIRING SHALL CONFORM TO IEE WIRING REGULATIONS. HEAT DETECTOR TO HAVE BATTERY BACKUP AND TO BE LOCATED A MIN. OF 300mm AWAY FROM ANY WALL AND LIGHT FITTING.

USB

DOUBLE S/W SOCKET OUTLET WITH USB (HIGH LEVEL)

COOKER CONNECTION UNIT

P 2 ZONE PROGRAMMER & HOT WATER TIMER

PT PROGRAMMABLE THERMOSTAT

FOR EXTENT OF TILING SEE SITE SPEC

COOKER SPACE: OPTIONAL SEPARATE ISOLATION SWITCH FOR MIN 30 AMP RADIAL COOKER CIRCUIT

BANK OF SWITCHES

32AMP ISOLATOR AND FUSED OUTLET FOR ELECTRIC HOB

OVEN/HOB SPACE 30AMP TAIL REQUIRED

COOKER SPACE: UNSWITCHED SOCKET REQUIRED. SEE LEGEND SHEET

SPACE FOR OPTIONAL FREESTANDING COOKER. FLOORING TO CONTINUE INTO SPACE. NO EXTRACTOR HOOD TO BE PROVIDED.

NBR dMEV C TO BE CEILING MOUNTED AND DUCTED THROUGH FLOOR VOID TO WALL TERMINAL. TO BE ISOLATED AT BANK OF SWITCHES

SPACE FOR WASHING MACHINE. UNSWITCHED SOCKET REQUIRED AT LOW LEVEL

100mm Ø INTERNAL DRAIN WITH AIR TIGHT SEAL FOR SINK WASTE

WATER ENTRY IN 100mm Ø INSULATED DUCT

NOTE: FOR STANDARD LIGHTING LAYOUT SEE DWG 601 FOR UPGRADE LIGHTING LAYOUT SEE DWG 760

BROOM

The diagram is a floor plan of a kitchen area. It shows a rectangular room with a dashed line indicating the extent of the flooring. Key features include:

 - Dimensions:** 373, 925, 360, 150, 170, 963, 600.
 - Annotations:**
 - SPACE FOR OPTIONAL FRIDGE FREEZER
 - SPACE FOR WASHING MACHINE. UNSWITCHED SOCKET REQUIRED AT LOW LEVEL
 - 100mm Ø INTERNAL DRAIN WITH AIR TIGHT SEAL FOR SINK WASTE
 - WATER ENTRY IN 100mm Ø INSULATED DUCT
 - FOR EXTENT OF TILING SEE SITE SPEC
 - COOKER SPACE: OPTIONAL SEPARATE ISOLATION SWITCH FOR MIN 30 AMP RADIAL COOKER CIRCUIT
 - BANK OF SWITCHES
 - 32AMP ISOLATOR AND FUSED OUTLET FOR ELECTRIC HOB
 - OVEN/HOB SPACE 30AMP TAIL REQUIRED
 - COOKER SPACE: UNSWITCHED SOCKET REQUIRED. SEE LEGEND SHEET
 - SPACE FOR OPTIONAL FREESTANDING COOKER. FLOORING TO CONTINUE INTO SPACE. NO EXTRACTOR HOOD TO BE PROVIDED.
 - NBR dMEV C TO BE CEILING MOUNTED AND DUCTED THROUGH FLOOR VOID TO WALL TERMINAL. TO BE ISOLATED AT BANK OF SWITCHES
 - Legend:** PELMET LIGHT FITTING, FUSED OUTLET (IMMERSION), ISOLATOR SWITCH, SINGLE SWITCH, DOUBLE SWITCH, TRIPLE SWITCH, NOTE: WHERE MULTIPLE SWITCHES ARE INDICATED TOGETHER THESE ARE TO BE SWITCHED ON ONE SINGLE PLATE NOT ON MULTIPLE PLATES., BANK OF SWITCHES TO ISOLATE HOB, EXTRACTOR HOOD, WASHING MACHINE, DISHWASHER, TUMBLE DRYER, FRIDGE/FREEZER, MICROWAVE OVEN, OPTIONAL WATER HEATER WITH NEON INDICATOR, ALL IN ACCORDANCE WITH THE APPLIANCE/SPACE PROVIDED ON LAYOUT., UNSWITCHED SOCKET / FUSED SPUR, TO BE CEILING MOUNTED, SEE STANDARD DETAILS, SINGLE UNSWITCHED SOCKET (HIGH LEVEL), SINGLE UNSWITCHED SOCKET (LOW LEVEL), SINGLE UNSWITCHED FUSED SPUR (LOW LEVEL), DOUBLE S/W SOCKET OUTLET (HIGH LEVEL), DOUBLE S/W SOCKET OUTLET (LOW LEVEL), HEAT DETECTOR TO BS EN 14604: 2005, TO BE PERMANENTLY WIRED TO A SEPARATELY FUSED CIRCUIT AT THE DISTRIBUTION BOARD. WHERE MORE THAN ONE ARE INSTALLED THEY WILL BE INTER-CONNECTED. WIRING SHALL CONFORM TO IEE WIRING REGULATIONS. HEAT DETECTOR TO HAVE BATTERY BACKUP AND TO BE LOCATED A MIN. OF 300mm AWAY FROM ANY WALL AND LIGHT FITTING., USB, DOUBLE S/W SOCKET OUTLET WITH USB (HIGH LEVEL), COOKER CONNECTION UNIT, P 2 ZONE PROGRAMMER & HOT WATER TIMER, PT PROGRAMMABLE THERMOSTAT.

A		System 3 extract indicated.		05.04.24	
2B4P M4(2)		Kitchen (Rental)		Dwg No 750	
Mid G SERIES		Scale 1:20		DCC 2	
		Date Mar 2023		Dwg Rev A	

This drawing must be read in conjunction with relevant Redrow specifications, standard details & structural calculations. All dimension are taken from face of Brick/Block & Studwork. This drawing is subject to copyright law. Do Not Scale Off This Drawing

ELECTRICAL LEGEND

-  PELMET LIGHT FITTING
-  FUSED OUTLET (IMMERSION)
-  ISOLATOR SWITCH
-  SINGLE SWITCH
-  DOUBLE SWITCH
-  TRIPLE SWITCH

NOTE: WHERE MULTIPLE SWITCHES ARE INDICATED TOGETHER THESE ARE TO BE SWITCHED ON ONE SINGLE PLATE NOT ON MULTIPLE PLATES.

-  BANK OF SWITCHES TO ISOLATE HOB, EXTRACTOR HOOD, WASHING MACHINE, DISHWASHER, TUMBLE DRYER, FRIDGE/FREEZER, MICROWAVE OVEN, OPTIONAL WATER HEATER WITH NEON INDICATOR, ALL IN ACCORDANCE WITH THE APPLIANCE/SPACE PROVIDED ON LAYOUT.

-  UNSWITCHED SOCKET / FUSED SPUR, TO BE CEILING MOUNTED, SEE STANDARD DETAILS

-  SINGLE UNSWITCHED SOCKET (HIGH LEVEL)

-  SINGLE UNSWITCHED SOCKET (LOW LEVEL)

-  SINGLE UNSWITCHED FUSED SPUR (LOW LEVEL)

-  DOUBLE S/W SOCKET OUTLET (HIGH LEVEL)

-  DOUBLE S/W SOCKET OUTLET (LOW LEVEL)


-  HEAT DETECTOR TO BS EN 14604: 2005, TO BE PERMANENTLY WIRED TO A SEPARATELY FUSED CIRCUIT AT THE DISTRIBUTION BOARD. WHERE MORE THAN ONE ARE INSTALLED THEY WILL BE INTER-CONNECTED. WIRING SHALL CONFORM TO IEE WIRING REGULATIONS. HEAT DETECTOR TO HAVE BATTERY BACKUP AND TO BE LOCATED A MIN. OF 300mm AWAY FROM ANY WALL AND LIGHT FITTING.

-  USB
 DOUBLE S/W SOCKET OUTLET WITH USB (HIGH LEVEL)

-  COOKER CONNECTION UNIT

-  P  2 ZONE PROGRAMMER & HOT WATER TIMER

-  PT  PROGRAMMABLE THERMOSTAT

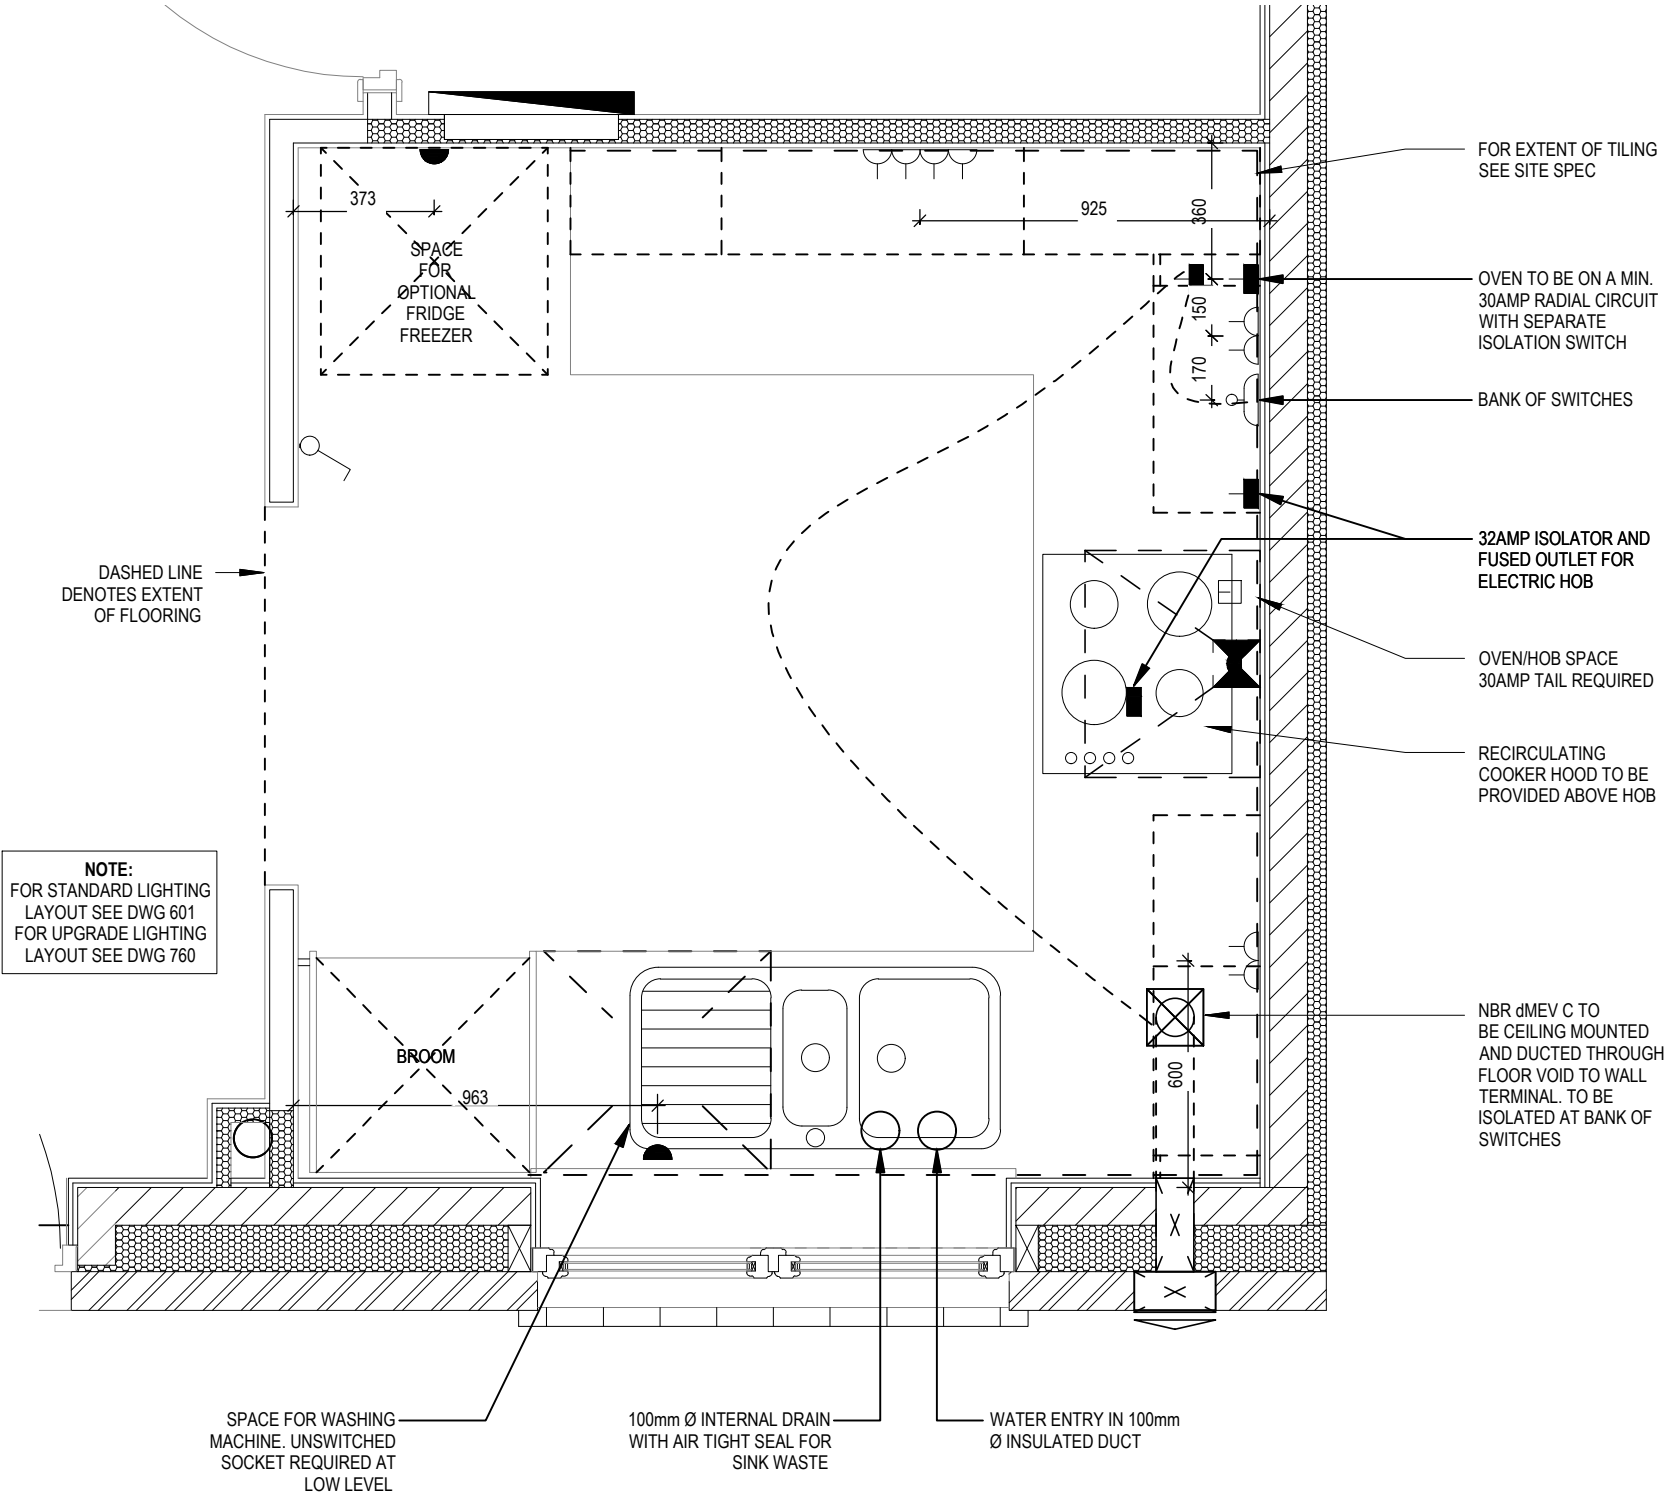

2B4P M4(2)

Mid
G SERIES

Kitchen (Shared Ownership)

Scale
1:20

DCC

Dwg No

751

Dwg Rev

B

Date

Mar 2023

B Sink amended to 1.5 bowl

A System 3 extract indicated


27.11.24

05.04.24


ELECTRICAL LEGEND

- OPTIONAL LOW VOLTAGE DOWNLIGHTER FITTING
- OPTIONAL PENDANT TYPE LIGHT FITTING
- INTERMITTENT MEV CEILING MOUNTED
- SINGLE SWITCH
- DOUBLE SWITCH
- TRIPLE SWITCH

NOTE: WHERE MULTIPLE SWITCHES ARE INDICATED TOGETHER THESE ARE TO BE SWITCHED ON ONE SINGLE PLATE NOT ON MULTIPLE PLATES.

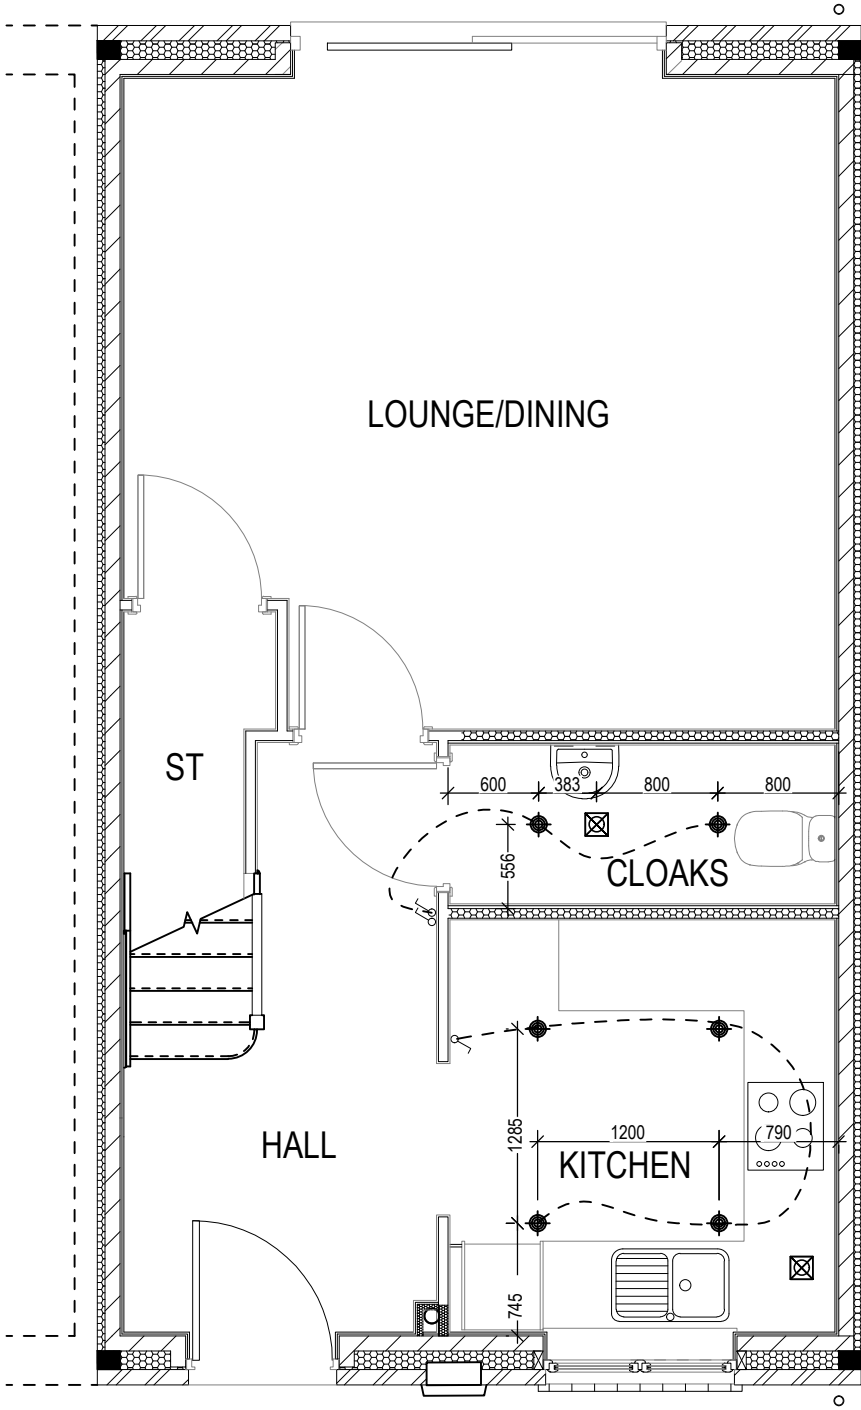

GROUND FLOOR

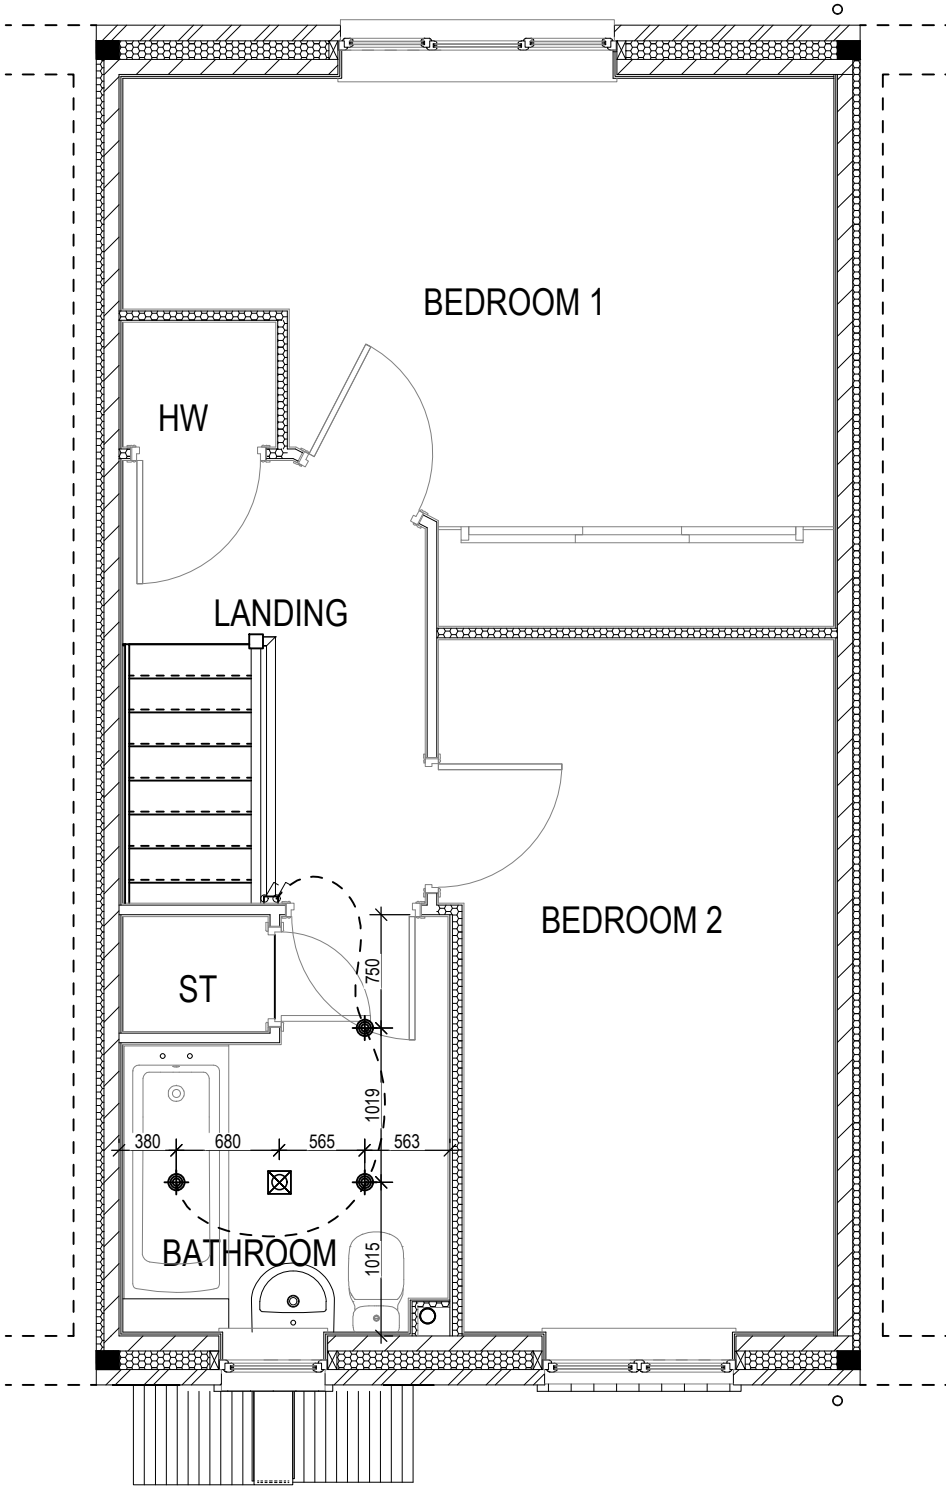

FIRST FLOOR

2B4P M4(2)
Mid
G SERIES

Optional Lighting Layouts
Shared Ownership Layouts

Scale
1 : 50
Date
Mar 2023
DCC
2
Dwg No
760
Dwg Rev
A

A 4No. downlighters to Kitchen & downlighter indicated to Cloaks 05.04.24